

PROJECT :    ADDITION

PROJECT ADDRESS : 180 PILGRIM RD, WEYMOUTH, MA



ARCHITECT:  
UP DESIGN & BUILD, LLC

EMAIL:  
INFO@UpDesignBuild.COM

PHONE:  
617-902 8626

PRELIMINARY CONCEPT,  
NOT VALID WITHOUT STAMP

180 PILGRIM RD

WEYMOUTH MA

PROJECT  
COVER SHEET

Project number            0.08

Date                        03/22/2022

Drawn by                    Author

Checked by                Checker

X00

Scale

DRAWING LIST:

SHEET #	DRAWING TITLE
00-GENERAL	
X00	PROJECT COVER SHEET
01 DEMO	
D01	DEMOLITION PLAN BASEMENT
D02	DEMOLITION PLAN FIRST LEVEL
D03	DEMOLITION PLAN SECOND LEVEL
01 PLANS	
A1	FOUNDATION PLAN PROPOSED
A2	FIRST FLOOR PLAN PROPOSED
A3	SECOND FLOOR PROPOSED
A4	ATTICPLAN - NEW
A5	ROOF PLAN- NEW
A7	STREET ELEVATION - EXISTING
A7a	STREET ELEVATION NEW
A8	RIGHT / WEST ELEVATION EXISTING
A8a	RIGHT / WEST ELEVATION PROPOSED
A9	REAR ELEVATION EXISTING
A9a	REAR ELEVATION - NEW
A10	LEFT/ EAST ELEVATION EXISTING
A10a	LEFT/ EAST ELEVATION PROPOSED
A11	SECTION 1
A12	3D VIEW
Grand total: 19	




EXISTING HOUSE

GENERAL NOTE:  
CONTRACTOR TO FIELD VERIFY AND COORDINATE WITH OWNER FOR ALL CONSTRUCTION ISSUES.  
THIS DRAWING SET IS TO SHOW DESIGN INTENT AND FOR PERMIT APPLICATION ONLY.

FIRE ALARM LEGEND	
③ SMOKE ALARM	Ⓢ CO/SMOKE COMBO

LEGEND :	
	EXISTING TO REMAIN
	DEMO
	NEW WORK

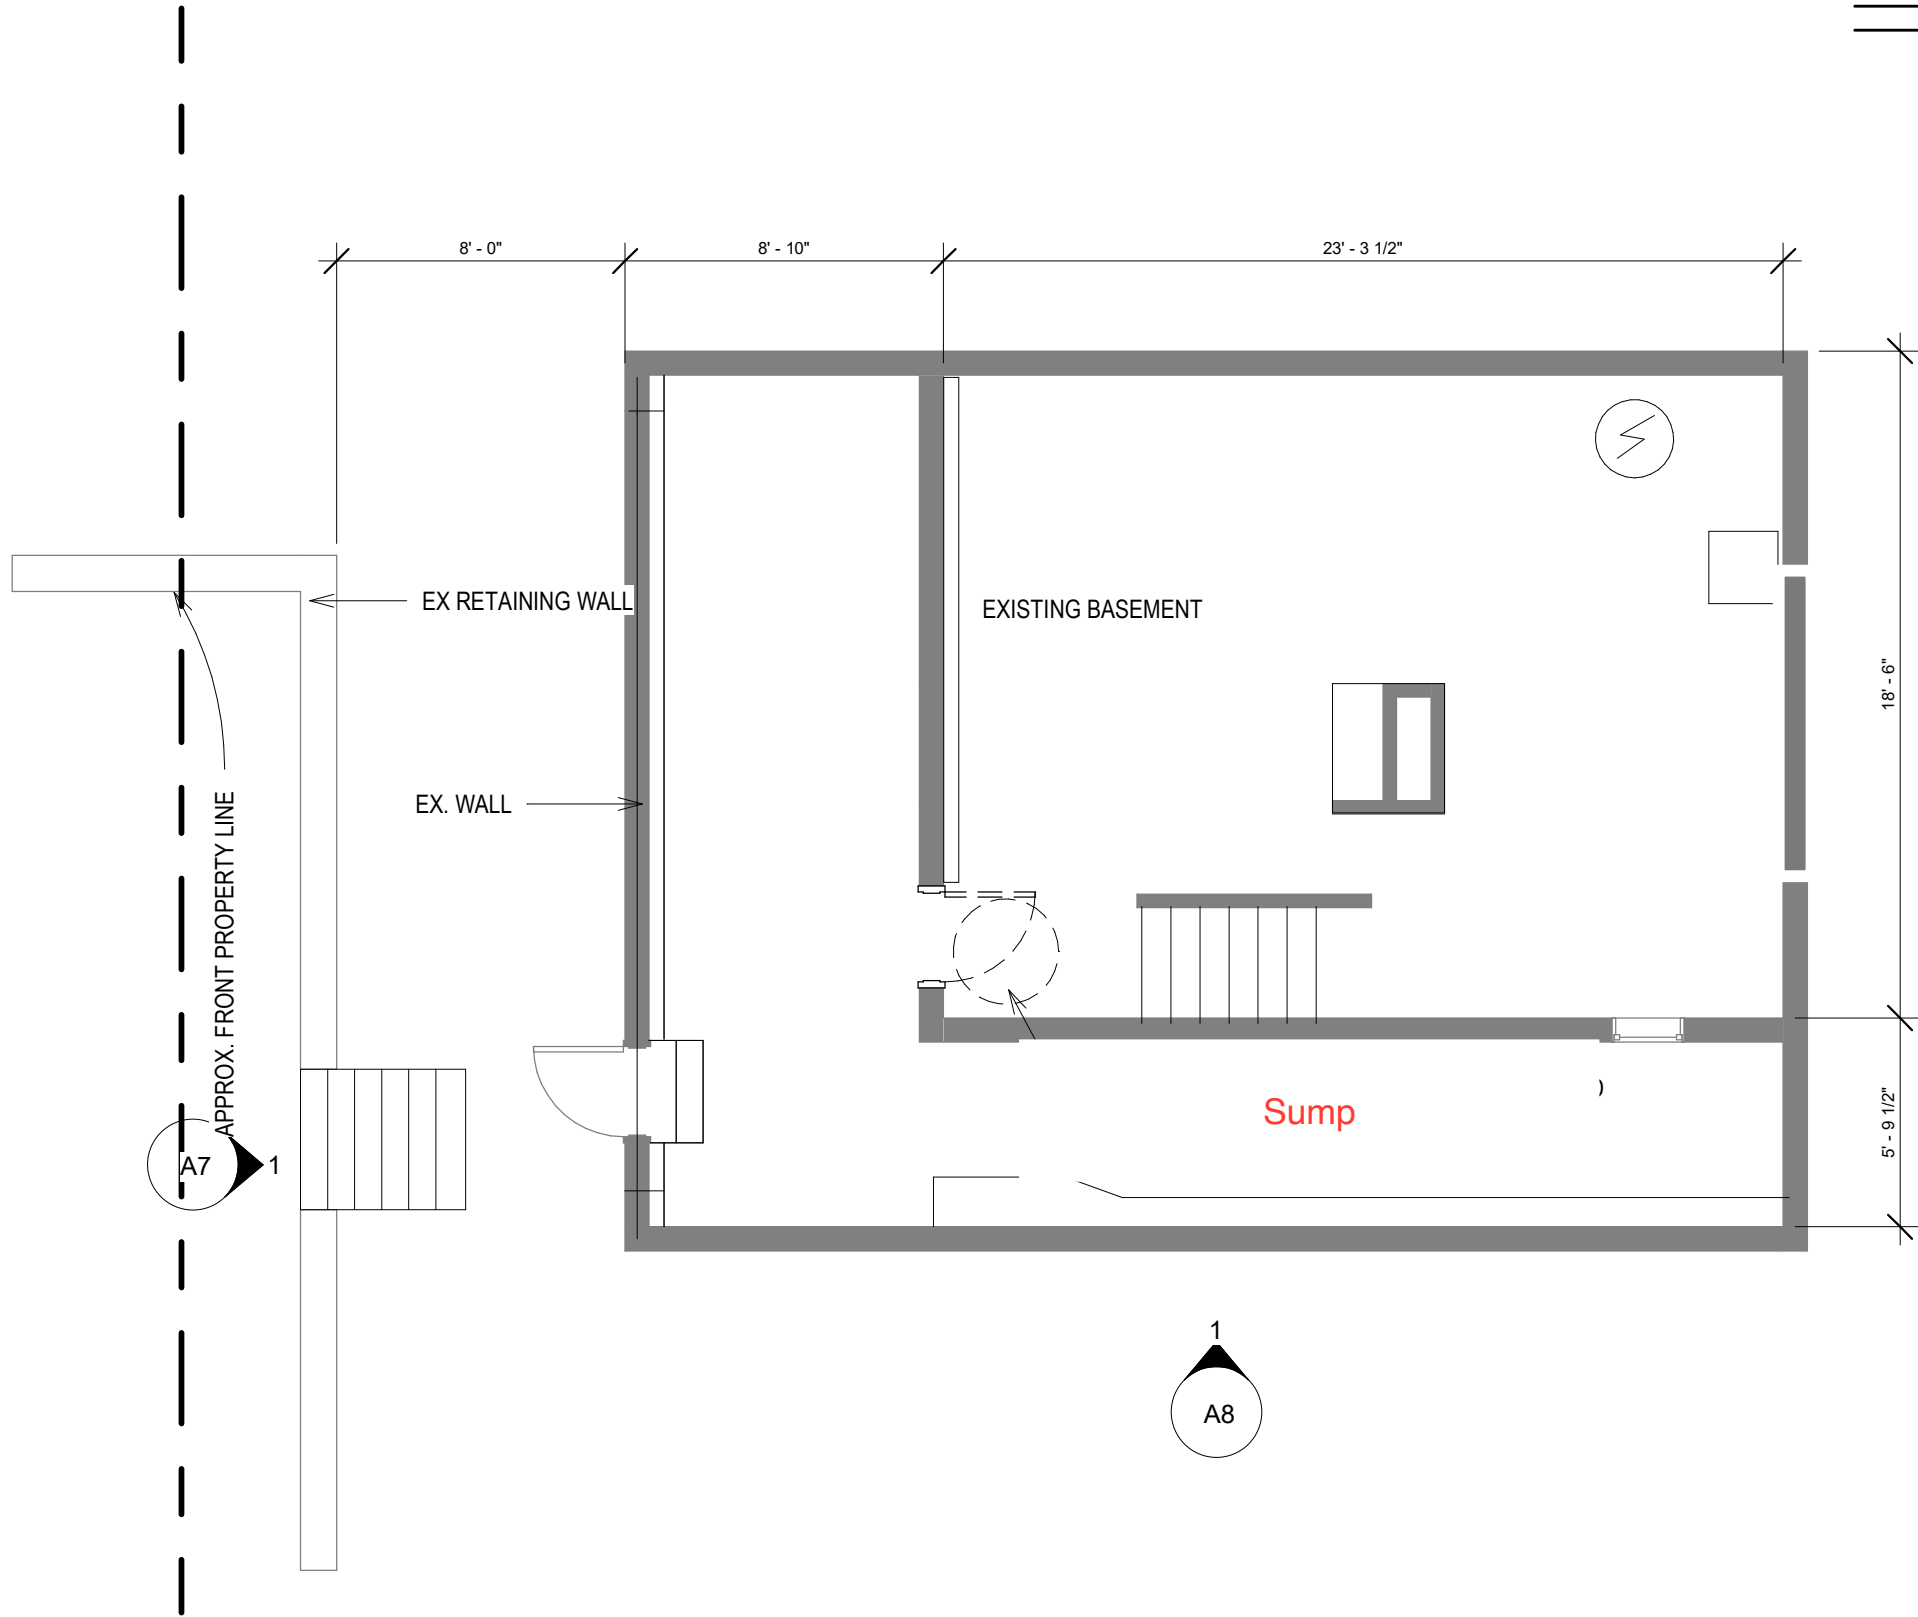

ARCHITECT:  
UP DESIGN & BUILD, LLC

EMAIL:  
INFO@UpDesignBuild.COM

PHONE:  
617-902 8626

PRELIMINARY CONCEPT,  
NOT VALID WITHOUT STAMP

180 PILGRIM RD  
  
WEYMOUTH MA


DEMOLITION  
PLAN  
BASEMENT

Project number	0.08
Date	03/22/2022
Drawn by	Author
Checked by	Checker
D01	
Scale	As indicated

GENERAL NOTE:  
CONTRACTOR TO FIELD VERIFY AND COORDINATE WITH OWNER FOR ALL CONSTRUCTION ISSUES.  
THIS DRAWING SET IS TO SHOW DESIGN INTENT AND FOR PERMIT APPLICATION ONLY.

FIRE ALARM LEGEND	
③ SMOKE ALARM	Ⓢ CO/SMOKE COMBO

LEGEND :	
	EXISTING TO REMAIN
	DEMO
	NEW WORK

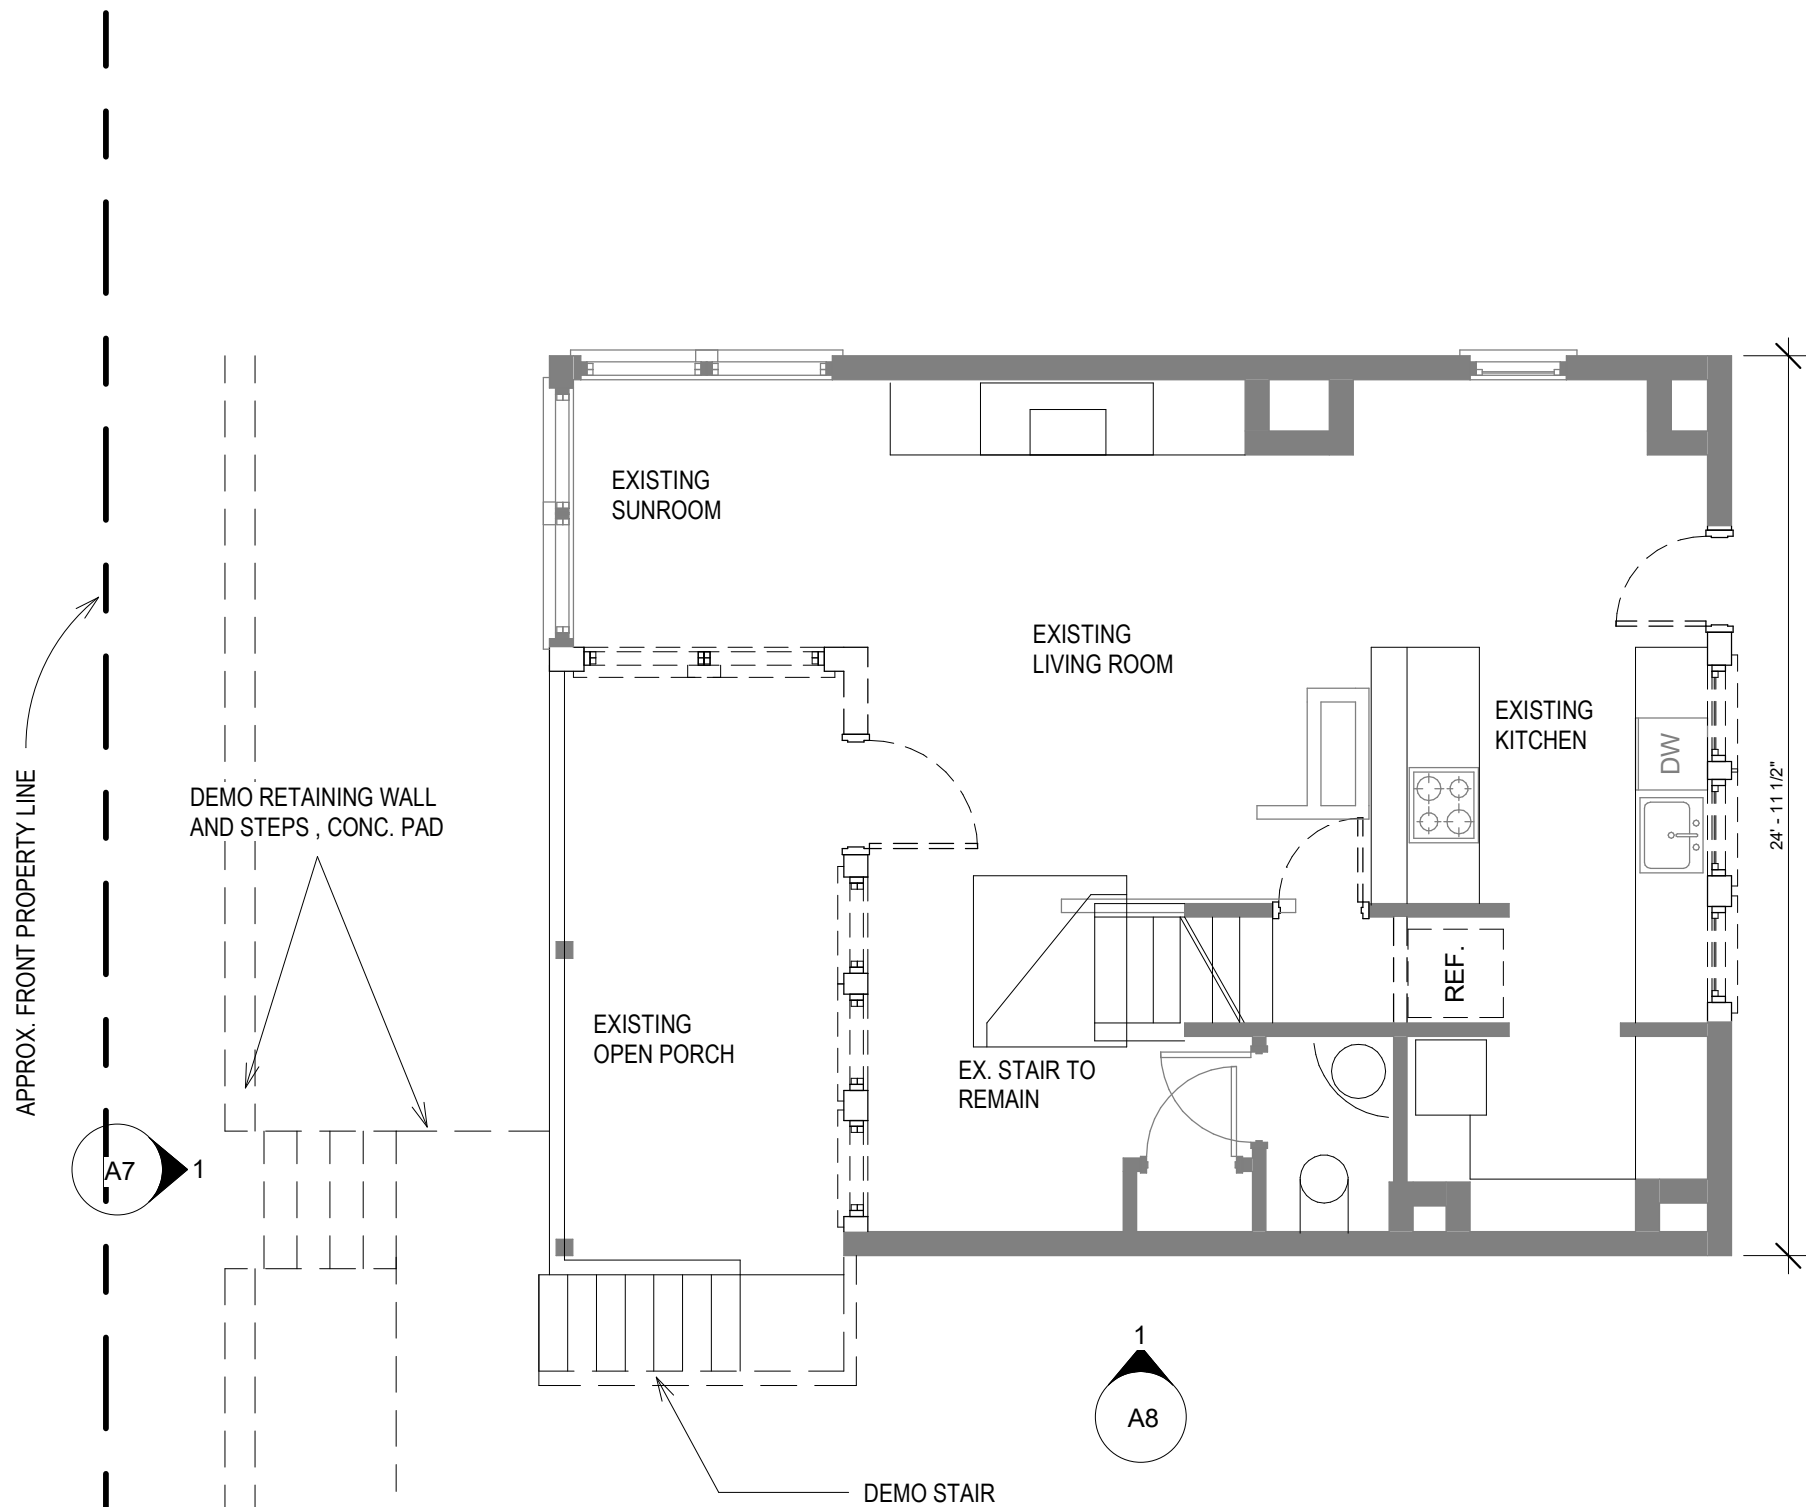


1  
D02

LEVEL 1 FLOOR PLAN EXISTING SHEET

Scale: 3/16" = 1'-0"

Ref: A7



ARCHITECT:  
UP DESIGN & BUILD, LLC

 
EMAIL:  
INFO@UpDesignBuild.COM

PHONE:  
617-902 8626

PRELIMINARY CONCEPT,  
NOT VALID WITHOUT STAMP

180 PILGRIM RD

WEYMOUTH MA



DEMOLITION PLAN FIRST LEVEL	
Project number	0.08
Date	03/22/2022
Drawn by	KX
Checked by	KX
D02	
Scale	As indicated

GENERAL NOTE:  
CONTRACTOR TO FIELD VERIFY AND COORDINATE WITH OWNER FOR ALL CONSTRUCTION ISSUES.  
THIS DRAWING SET IS TO SHOW DESIGN INTENT AND FOR PERMIT APPLICATION ONLY.

FIRE ALARM LEGEND

 
③ SMOKE ALARM

Ⓢ CO/SMOKE COMBO


LEGEND :




EXISTING TO REMAIN



DEMO

 

NEW WORK

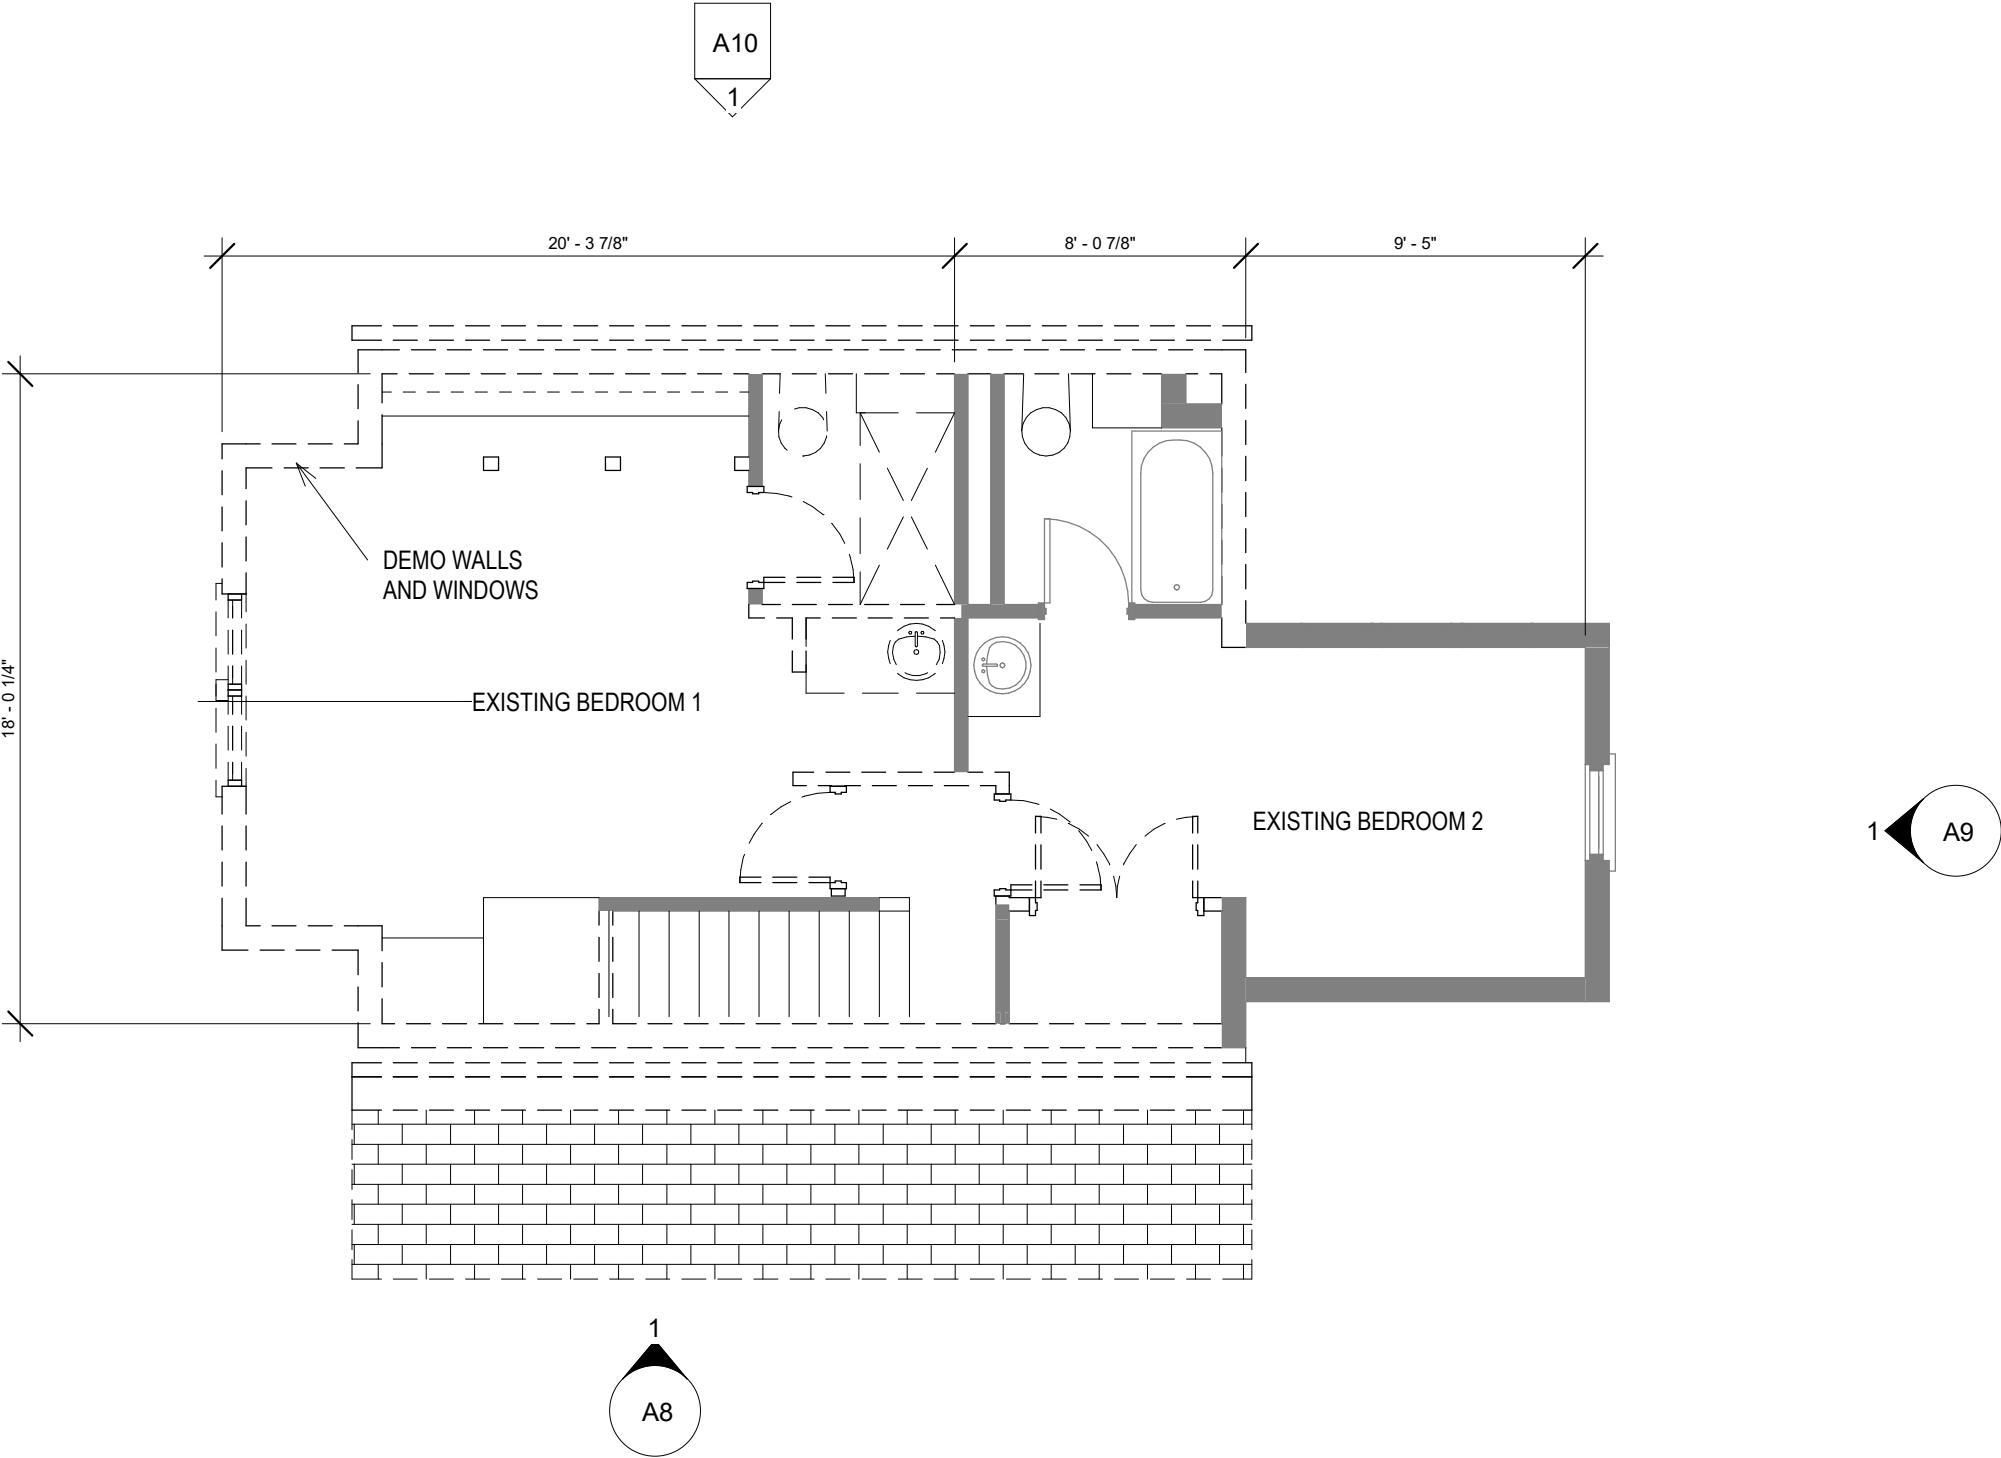

ARCHITECT:  
UP DESIGN & BUILD, LLC

EMAIL:  
INFO@UpDesignBuild.COM

PHONE:  
617-902 8626

PRELIMINARY CONCEPT,  
NOT VALID WITHOUT STAMP

180 PILGRIM RD

WEYMOUTH MA

DEMOLITION  
PLAN  
SECOND  
LEVEL

Project number 0.08

Date 03/22/2022

Drawn by Author

Checked by Checker

D03

Scale As indicated

GENERAL NOTE:  
CONTRACTOR TO FIELD VERIFY AND COORDINATE WITH OWNER FOR ALL CONSTRUCTION ISSUES.  
THIS DRAWING SET IS TO SHOW DESIGN INTENT AND FOR PERMIT APPLICATION ONLY.

FIRE ALARM LEGEND

③

SMOKE ALARM

Ⓢ

CO/SMOKE COMBO

LEGEND :

EXISTING TO REMAIN

DEMO

NEW WORK

UP

DESIGN & BUILD

ARCHITECT:  
UP DESIGN & BUILD, LLC

EMAIL:  
INFO@UpDesignBuild.COM

PHONE:  
617-902 8626

PRELIMINARY CONCEPT,  
NOT VALID WITHOUT STAMP

180 PILGRIM RD

WEYMOUTH MA

FOUNDATION  
PLAN  
PROPOSED

Project number0.08

Date03/22/2022

Drawn byAuthor

Checked byChecker

A1


ScaleAs indicated

3/22/2022 5:28:22 PM

1

A1

FOUNDATION PLAN n  
Scale: 3/16" = 1'-0"

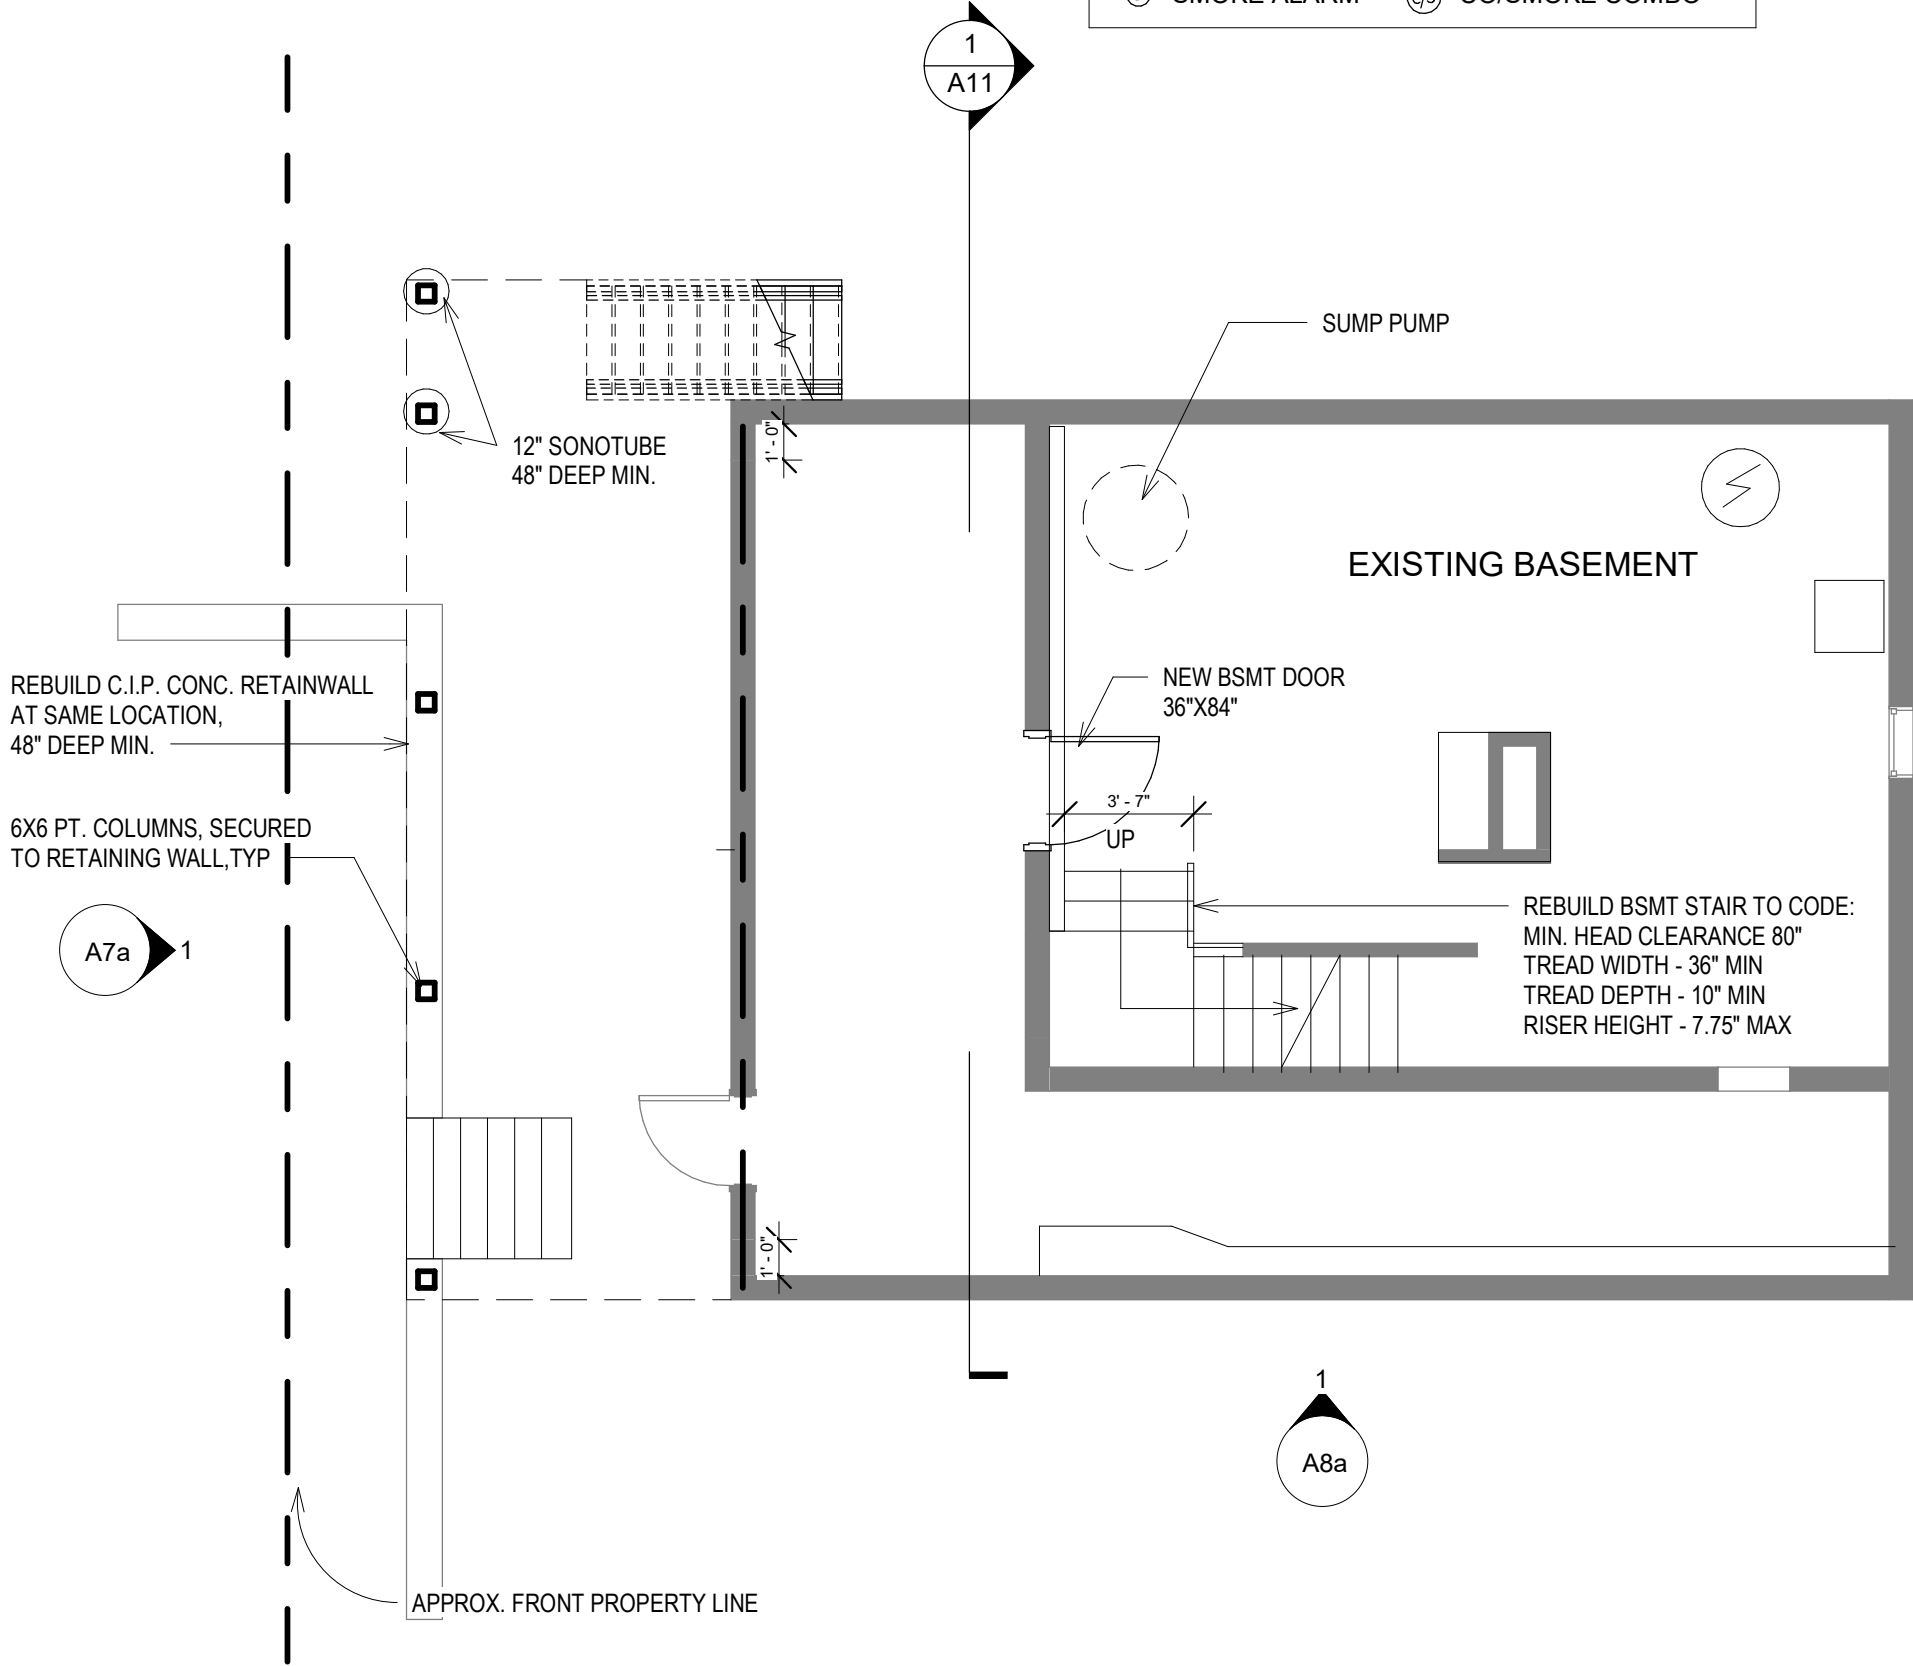


GENERAL NOTE:  
CONTRACTOR TO FIELD VERIFY AND COORDINATE WITH OWNER FOR ALL CONSTRUCTION ISSUES.  
THIS DRAWING SET IS TO SHOW DESIGN INTENT AND FOR PERMIT APPLICATION ONLY.

NOTES:  
ALL NEW STAIR TO MEET CODE, MAX. RISER 7 3/4", MIN TREAD 10".

ALL NEW INTERIOR DOORS TO BE 32"X80", CONFIRM WITH OWNER BEFORE CONSTRUCTION.

FIRE ALARM LEGEND	
Ⓢ	SMOKE ALARM
Ⓢ/ⓐ	CO/SMOKE COMBO

LEGEND :	
	EXISTING TO REMAIN
	DEMO
	NEW WORK



ARCHITECT:  
UP DESIGN & BUILD, LLC

EMAIL:  
INFO@UpDesignBuild.COM

PHONE:  
617-902 8626

PRELIMINARY CONCEPT,  
NOT VALID WITHOUT STAMP

180 PILGRIM RD  
  
WEYMOUTH MA

FIRST FLOOR  
PLAN  
PROPOSED

Project number 0.08


Date 03/22/2022

Drawn by Author

Checked by Checker

A2

Scale As indicated

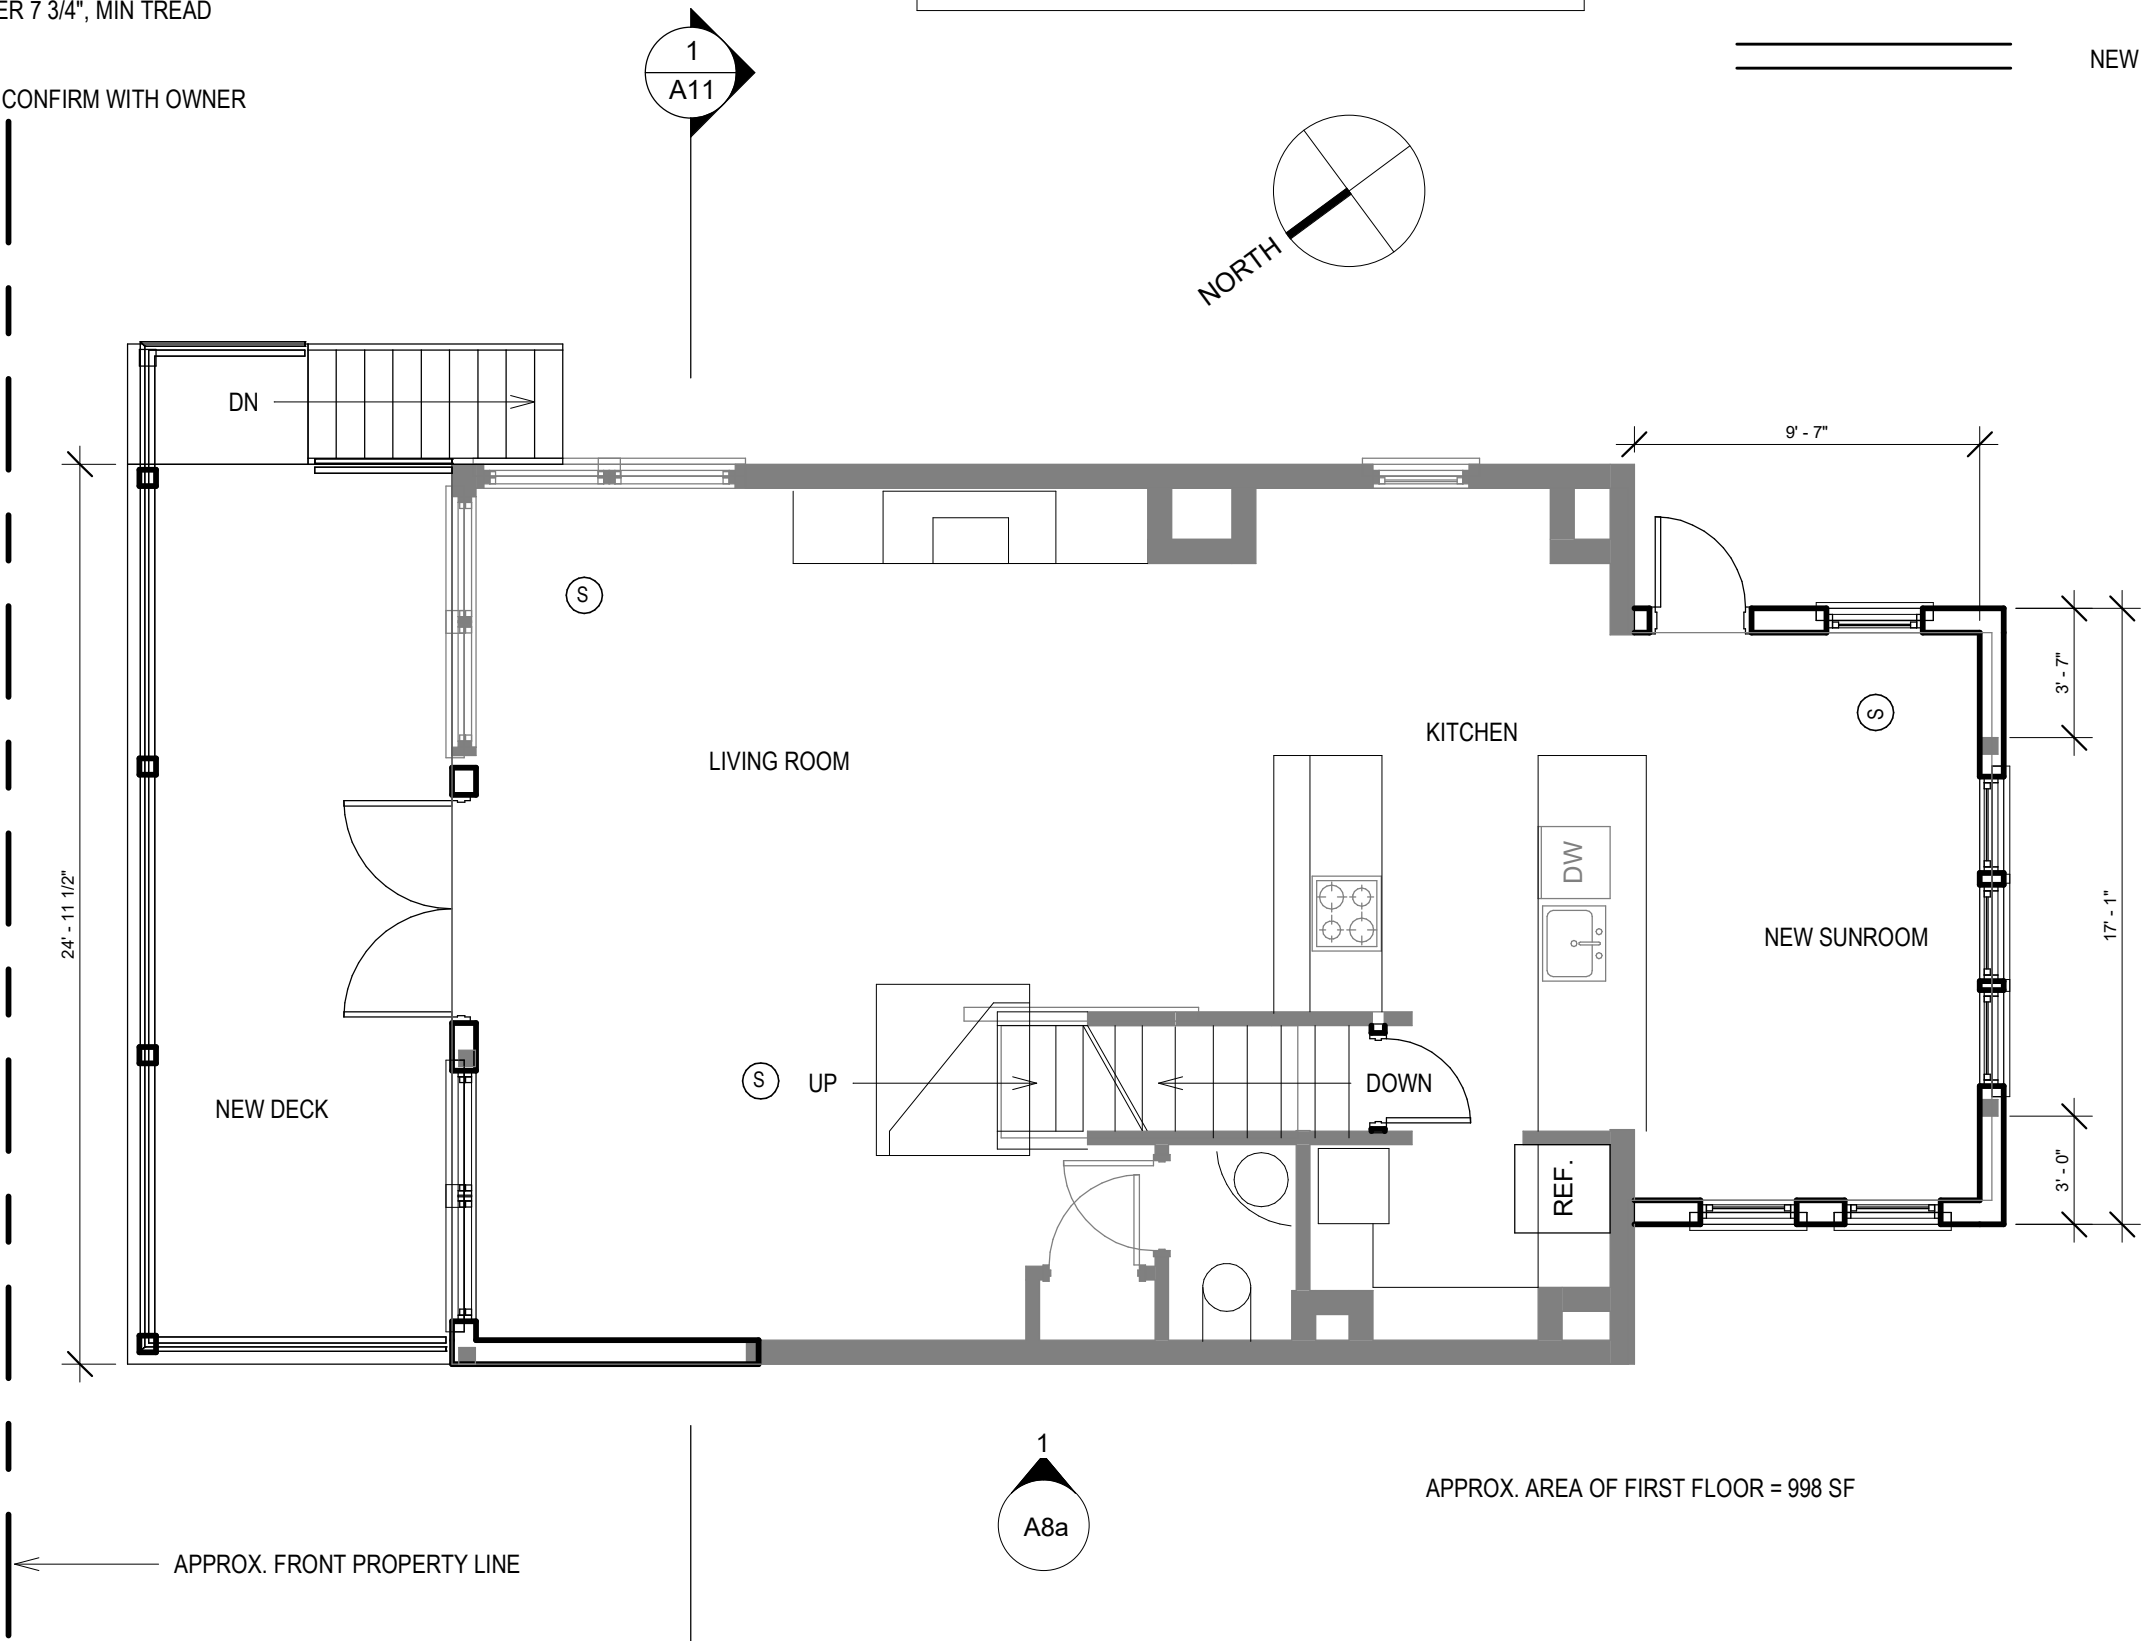

1 LEVEL 1 FLOOR PLAN NEW WORK  
A2 Scale: 3/16" = 1'-0" Ref: A7

3/22/2022 5:28:22 PM

GENERAL NOTE:  
CONTRACTOR TO FIELD VERIFY AND COORDINATE WITH OWNER FOR ALL CONSTRUCTION ISSUES.  
THIS DRAWING SET IS TO SHOW DESIGN INTENT AND FOR PERMIT APPLICATION ONLY.

FIRE ALARM LEGEND			
①	SMOKE ALARM	Ⓢ	CO/SMOKE COMBO

LEGEND :	
	EXISTING TO REMAIN
	DEMO
	NEW WORK

ARCHITECT:  
UP DESIGN & BUILD, LLC

EMAIL:  
INFO@UpDesignBuild.COM

PHONE:  
617-902 8626

PRELIMINARY CONCEPT,  
NOT VALID WITHOUT STAMP


180 PILGRIM RD  
  
WEYMOUTH MA

SECOND  
FLOOR  
PROPOSED

Project number	0.08
Date	03/22/2022
Drawn by	KX
Checked by	KX

A3

Scale As indicated

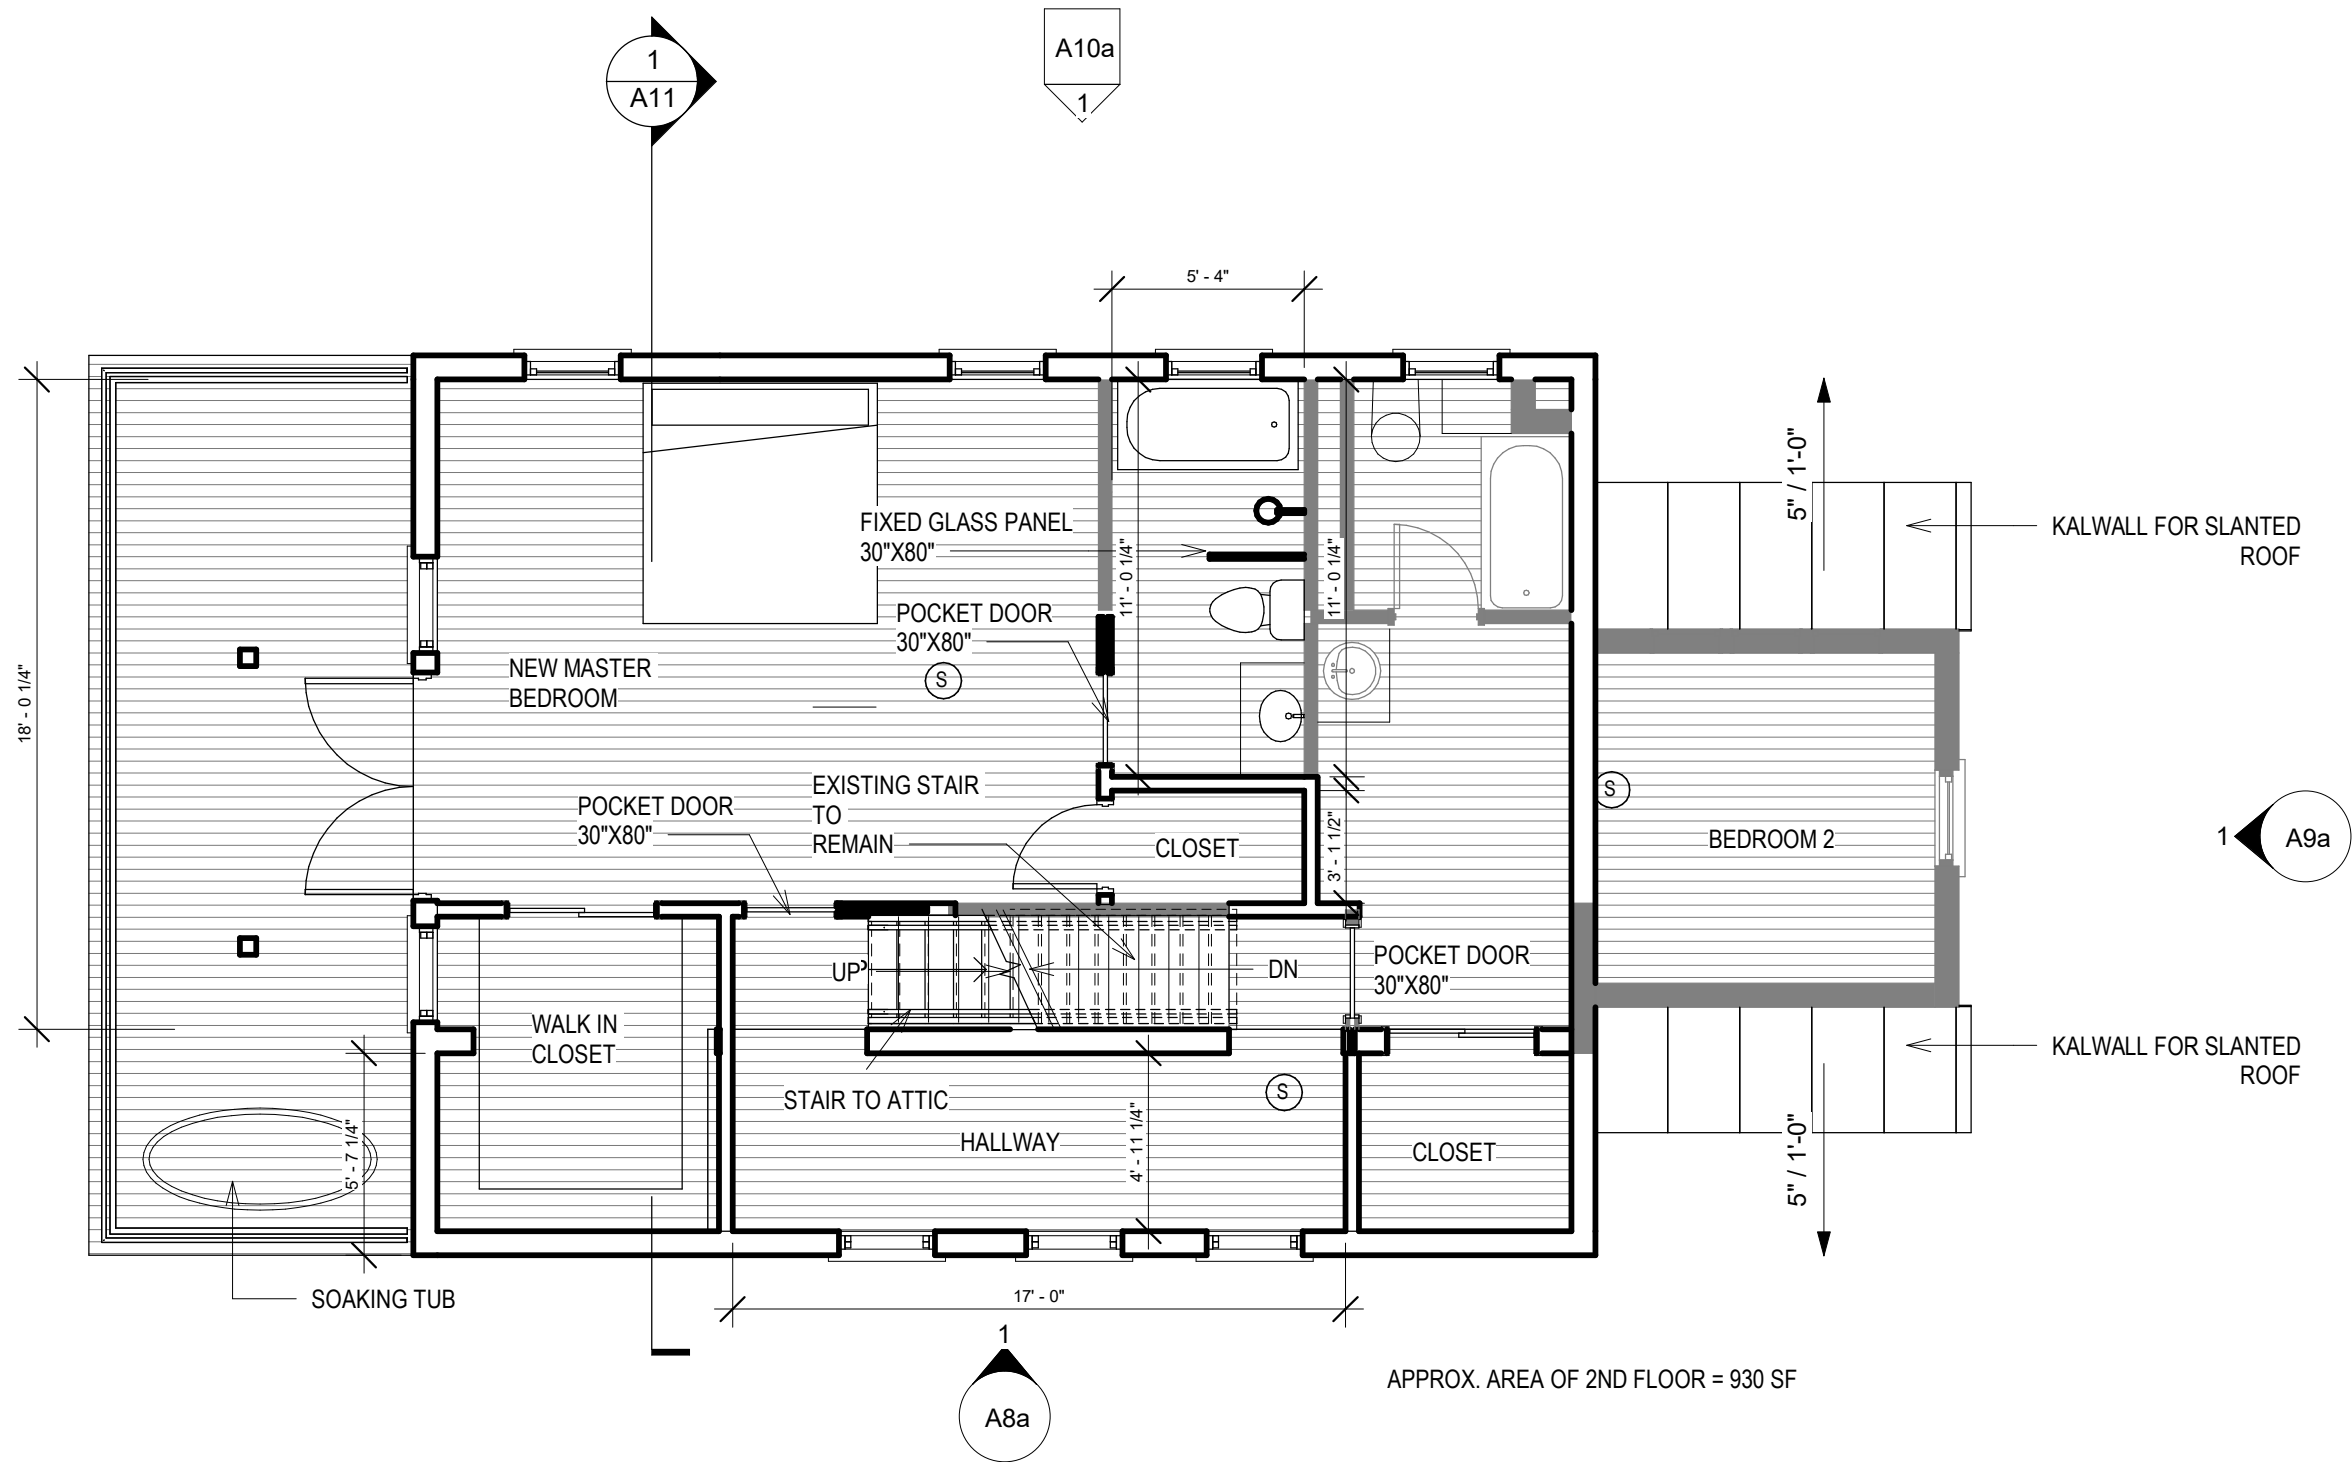

1  
A3 LEVEL 2 FLOOR PLAN PROPOSED CONCEPT  
Scale: 3/16" = 1'-0"

3/22/2022 5:28:23 PM



GENERAL NOTE:  
CONTRACTOR TO FIELD VERIFY AND COORDINATE WITH OWNER FOR ALL CONSTRUCTION ISSUES.  
THIS DRAWING SET IS TO SHOW DESIGN INTENT AND FOR PERMIT APPLICATION ONLY.

 
FIRE ALARM LEGEND

① SMOKE ALARM    Ⓢ CO/SMOKE COMBO


LEGEND :



EXISTING TO REMAIN



DEMO

 

NEW WORK



ARCHITECT:  
UP DESIGN & BUILD, LLC

EMAIL:  
INFO@UpDesignBuild.COM

PHONE:  
617-902 8626

PRELIMINARY CONCEPT,  
NOT VALID WITHOUT STAMP

180 PILGRIM RD

WEYMOUTH MA

ATTICPLAN -  
NEW

Project number    0.08


Date    03/22/2022

Drawn by    Author

Checked by    Checker

A4

Scale    As indicated

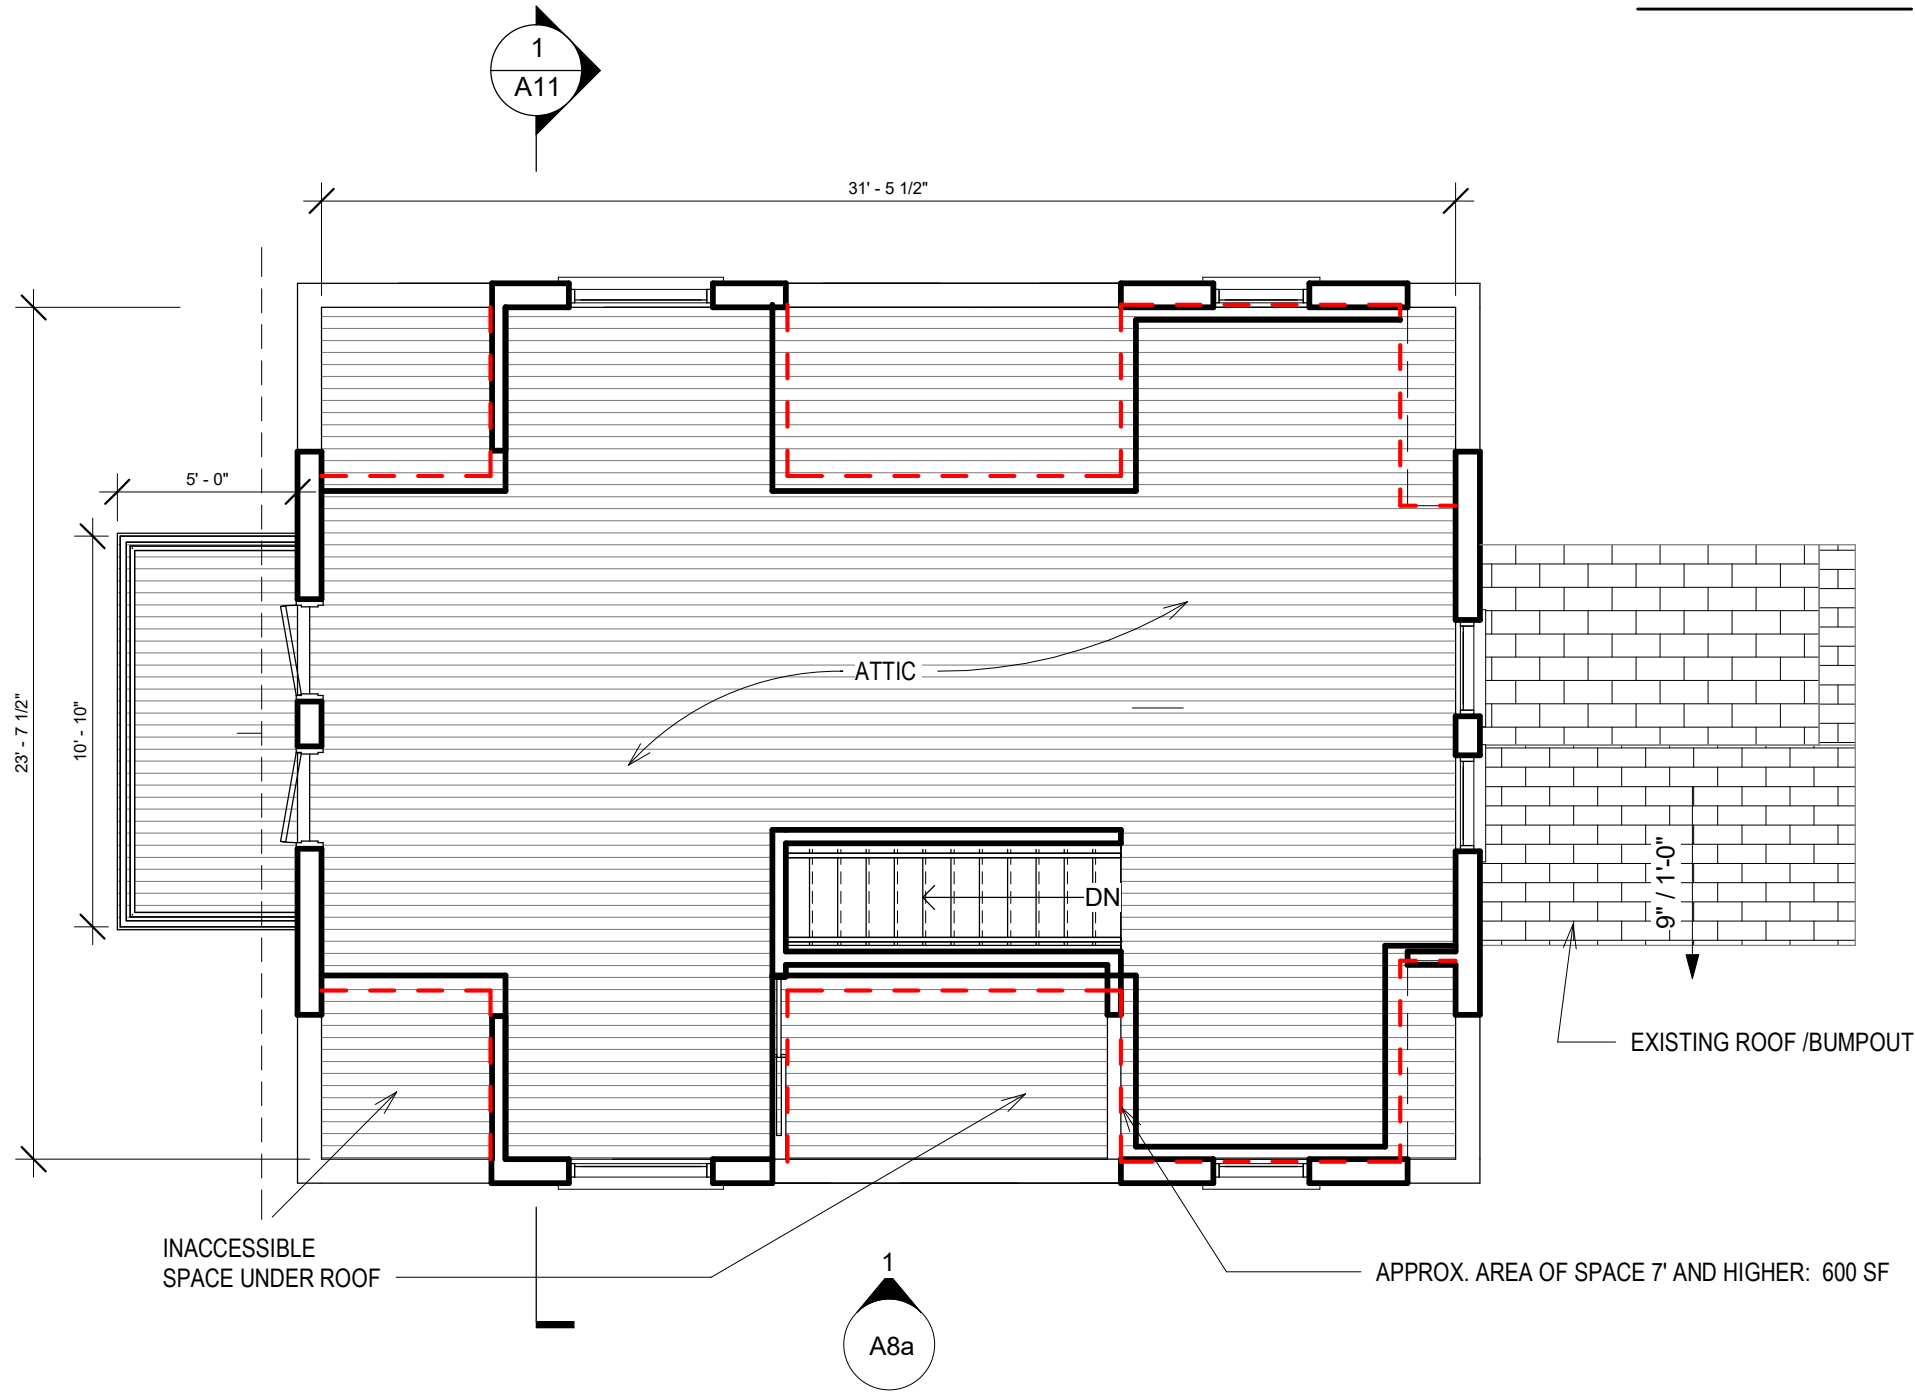


 
 
1 ATTIC  
A4 Scale: 3/16" = 1'-0"

Ref: A7



GENERAL NOTE:  
CONTRACTOR TO FIELD VERIFY AND COORDINATE WITH OWNER FOR ALL CONSTRUCTION ISSUES.  
THIS DRAWING SET IS TO SHOW DESIGN INTENT AND FOR PERMIT APPLICATION ONLY.

FIRE ALARM LEGEND	
① SMOKE ALARM	Ⓢ CO/SMOKE COMBO

LEGEND :	
	EXISTING TO REMAIN
	DEMO
	NEW WORK



ARCHITECT:  
UP DESIGN & BUILD, LLC

EMAIL:  
INFO@UpDesignBuild.COM

PHONE:  
617-902 8626

PRELIMINARY CONCEPT,  
NOT VALID WITHOUT STAMP

180 PILGRIM RD  
  
WEYMOUTH MA

ROOF PLAN-  
NEW

Project number 0.08


Date 03/22/2022

Drawn by Author

Checked by Checker

A5

Scale As indicated

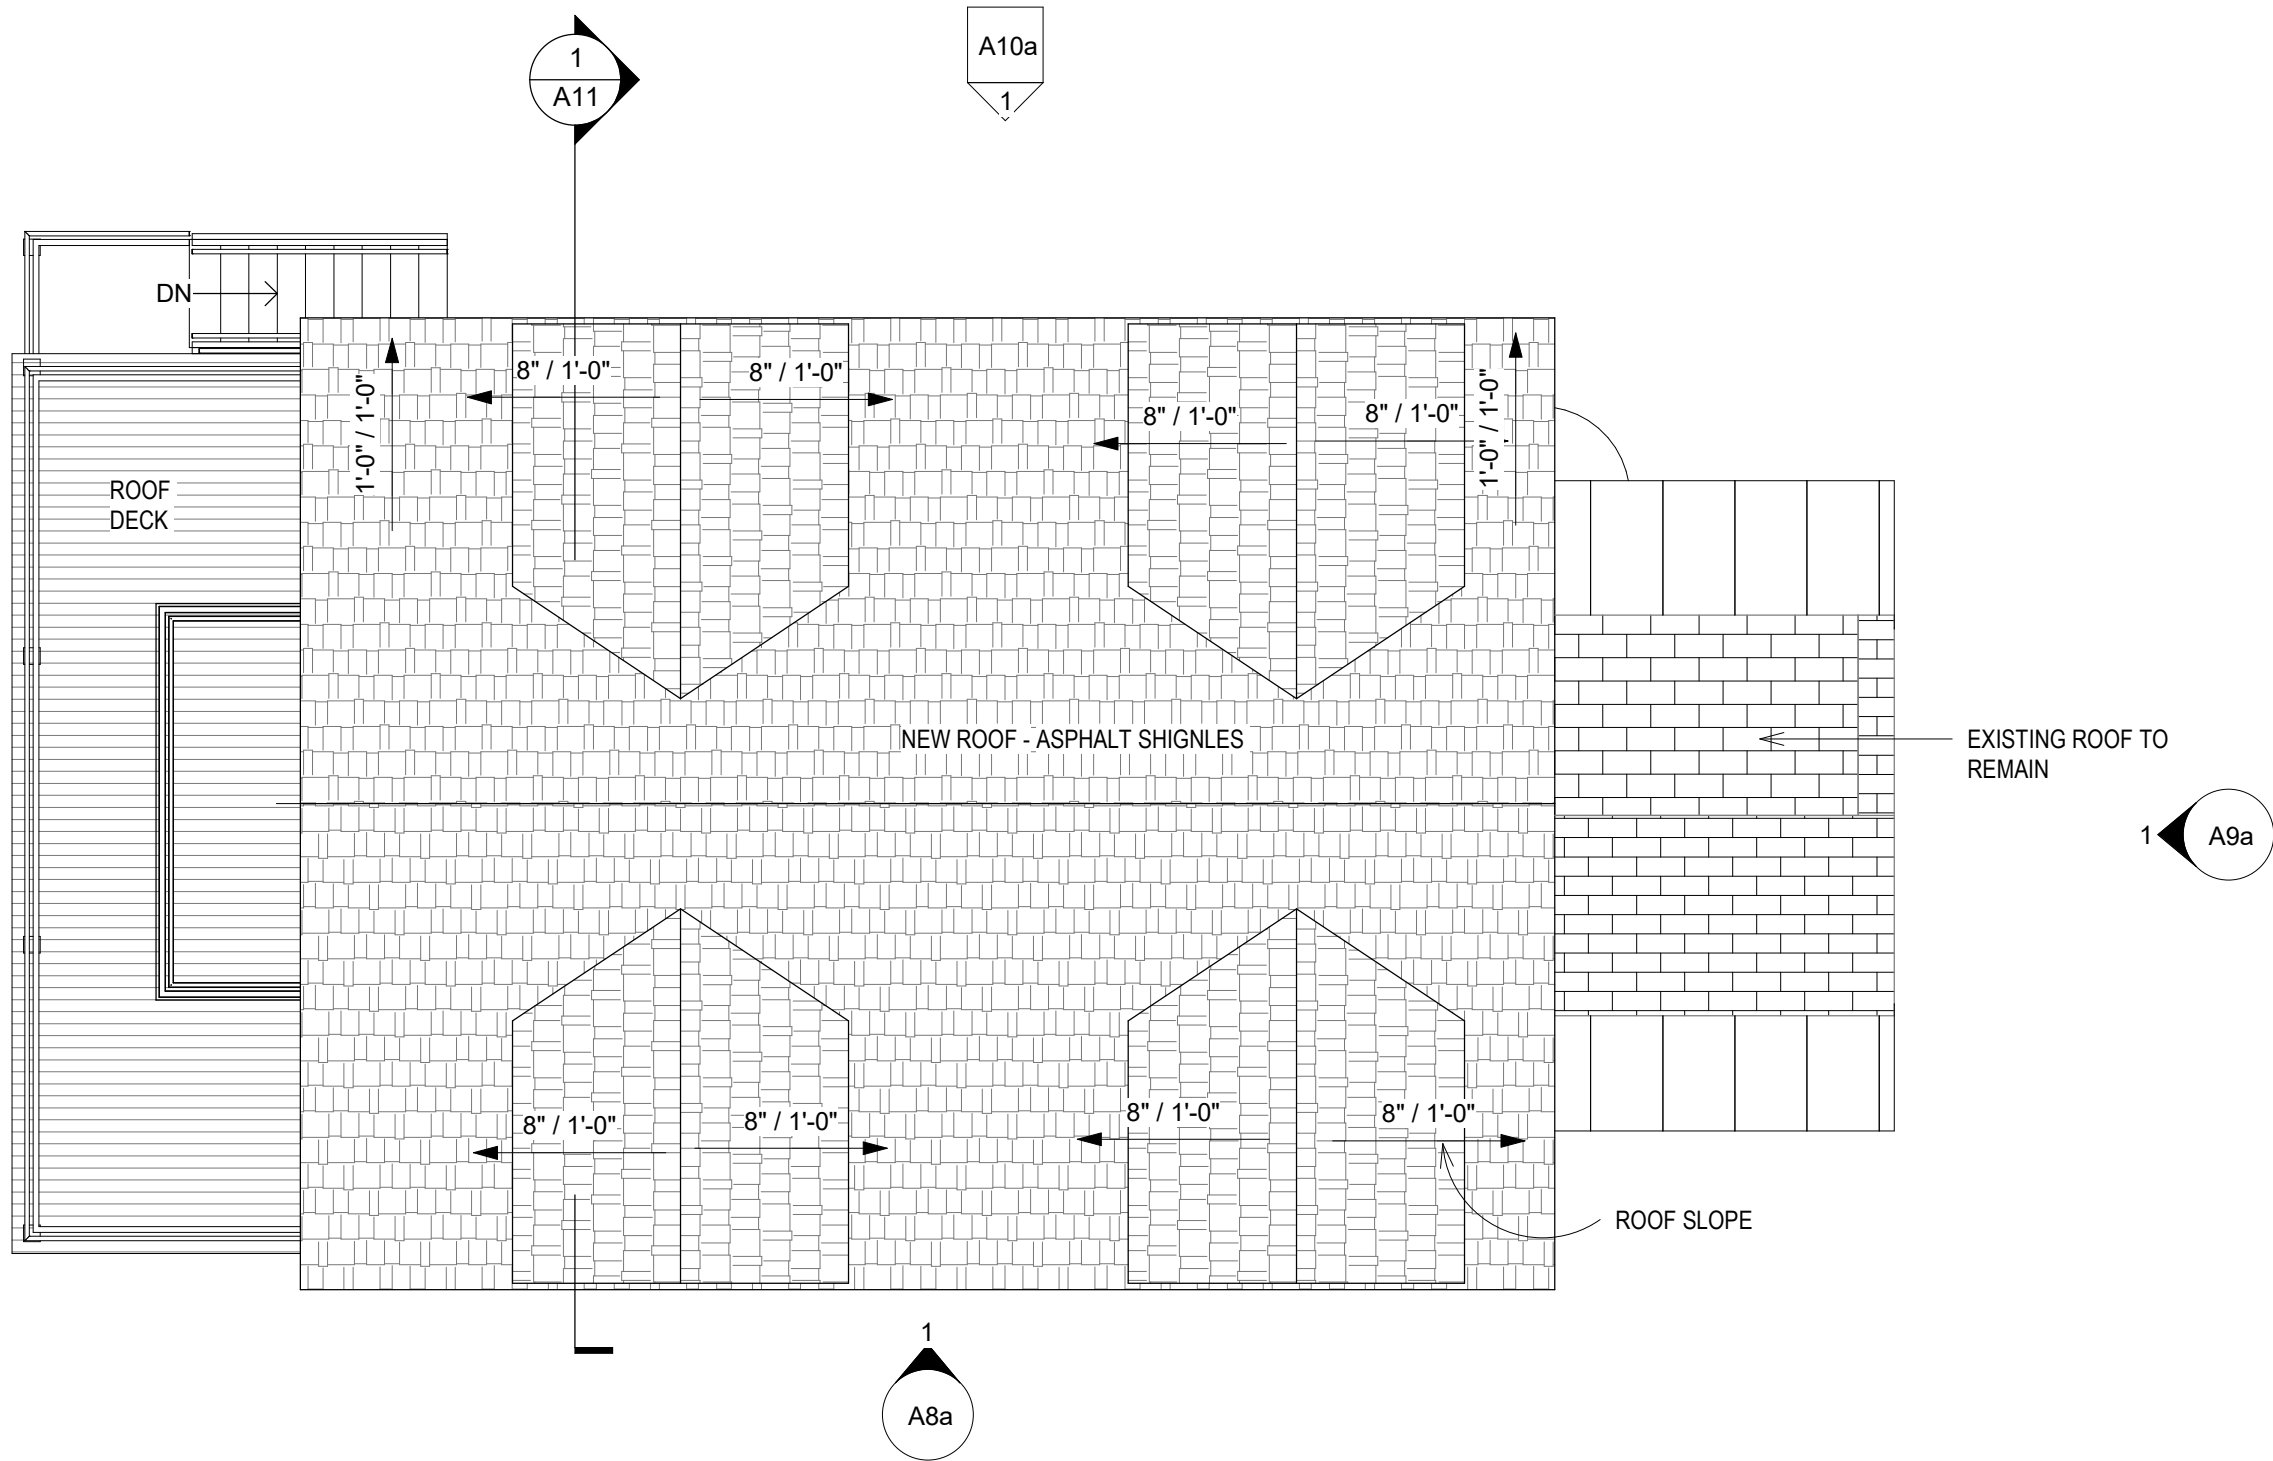

A7a 1

1 ROOF PLAN - NEW  
A5 Scale: 3/16" = 1'-0"

1  
A8a

1  
A9a

A10a  
1

1  
A11

GENERAL NOTE:  
CONTRACTOR TO FIELD VERIFY AND COORDINATE WITH OWNER FOR ALL CONSTRUCTION ISSUES.  
THIS DRAWING SET IS TO SHOW DESIGN INTENT AND FOR PERMIT APPLICATION ONLY.

FIRE ALARM LEGEND

 
⑤ SMOKE ALARM

Ⓢ CO/SMOKE COMBO


LEGEND :




EXISTING TO REMAIN



DEMO

 

NEW WORK

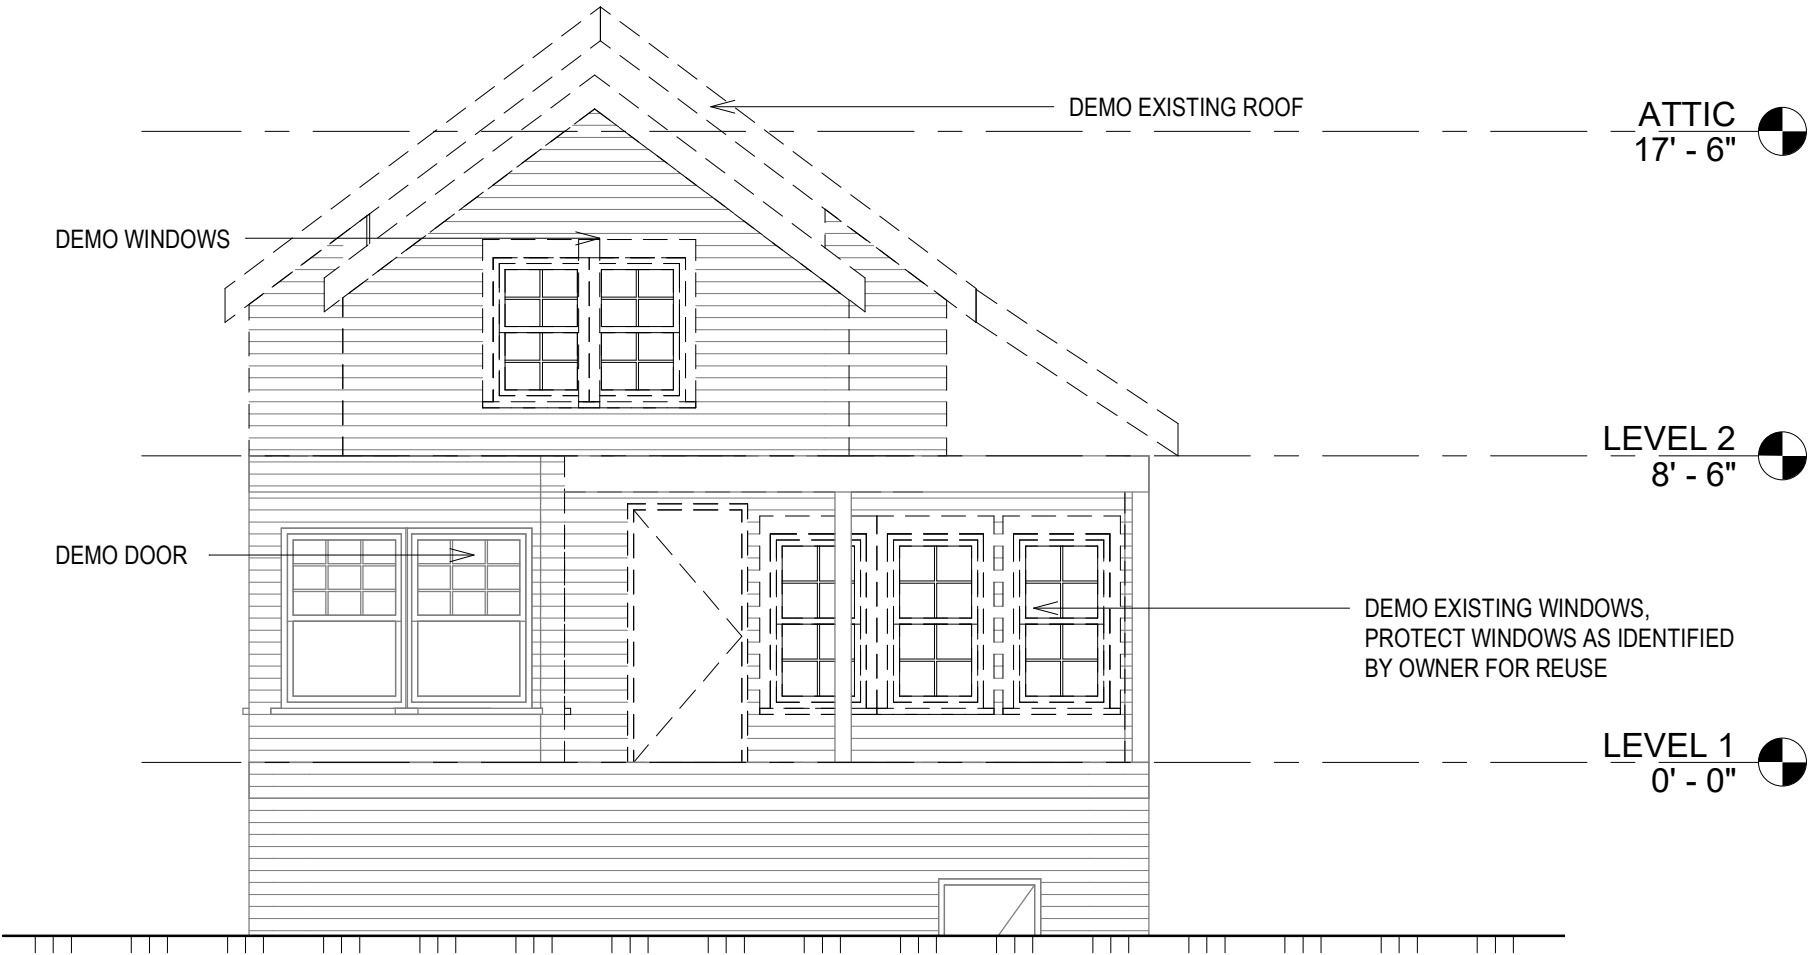

1  
A7

STREET ELEVATION EX

Scale: 3/16" = 1'-0"

Ref: D01



ARCHITECT:  
UP DESIGN & BUILD, LLC

EMAIL:  
INFO@UpDesignBuild.COM

PHONE:  
617-902 8626

PRELIMINARY CONCEPT,  
NOT VALID WITHOUT STAMP

180 PILGRIM RD

WEYMOUTH MA

STREET  
ELEVATION -  
EXISTING

Project number 0.08

Date 03/22/2022

Drawn by Author

Checked by Checker

A7

Scale As indicated


3/22/2022 5:28:25 PM

GENERAL NOTE:  
CONTRACTOR TO FIELD VERIFY AND COORDINATE WITH OWNER FOR ALL CONSTRUCTION ISSUES.  
THIS DRAWING SET IS TO SHOW DESIGN INTENT AND FOR PERMIT APPLICATION ONLY.

FIRE ALARM LEGEND

Ⓢ SMOKE ALARM    Ⓢ CO/SMOKE COMBO

LEGEND :

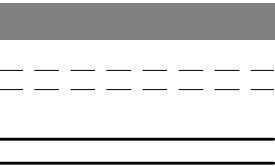

EXISTING TO REMAIN

DEMO

NEW WORK



ARCHITECT:  
UP DESIGN & BUILD, LLC

EMAIL:  
INFO@UpDesignBuild.COM

PHONE:  
617-902 8626

PRELIMINARY CONCEPT,  
NOT VALID WITHOUT STAMP

180 PILGRIM RD

WEYMOUTH MA

STREET  
ELEVATION  
NEW

Project number    0.08

Date    03/22/2022

Drawn by    Author

Checked by    Checker

A7a

Scale    As indicated



1

A7a

STREET ELEVATION - PROPOSED

Scale: 3/16" = 1'-0"

Ref: A1

3/22/2022 5:28:25 PM

GENERAL NOTE:  
CONTRACTOR TO FIELD VERIFY AND COORDINATE WITH OWNER FOR ALL CONSTRUCTION ISSUES.  
THIS DRAWING SET IS TO SHOW DESIGN INTENT AND FOR PERMIT APPLICATION ONLY.

FIRE ALARM LEGEND

⑤ SMOKE ALARM    c/s CO/SMOKE COMBO

LEGEND :

EXISTING TO REMAIN  
DEMO  
NEW WORK



ARCHITECT:  
UP DESIGN & BUILD, LLC

EMAIL:  
INFO@UpDesignBuild.COM

PHONE:  
617-902 8626

PRELIMINARY CONCEPT,  
NOT VALID WITHOUT STAMP

180 PILGRIM RD

WEYMOUTH MA

RIGHT / WEST  
ELEVATION  
EXISTING

Project number      0.08


Date                    03/22/2022

Drawn by              Author

Checked by            Checker

A8

Scale      As indicated

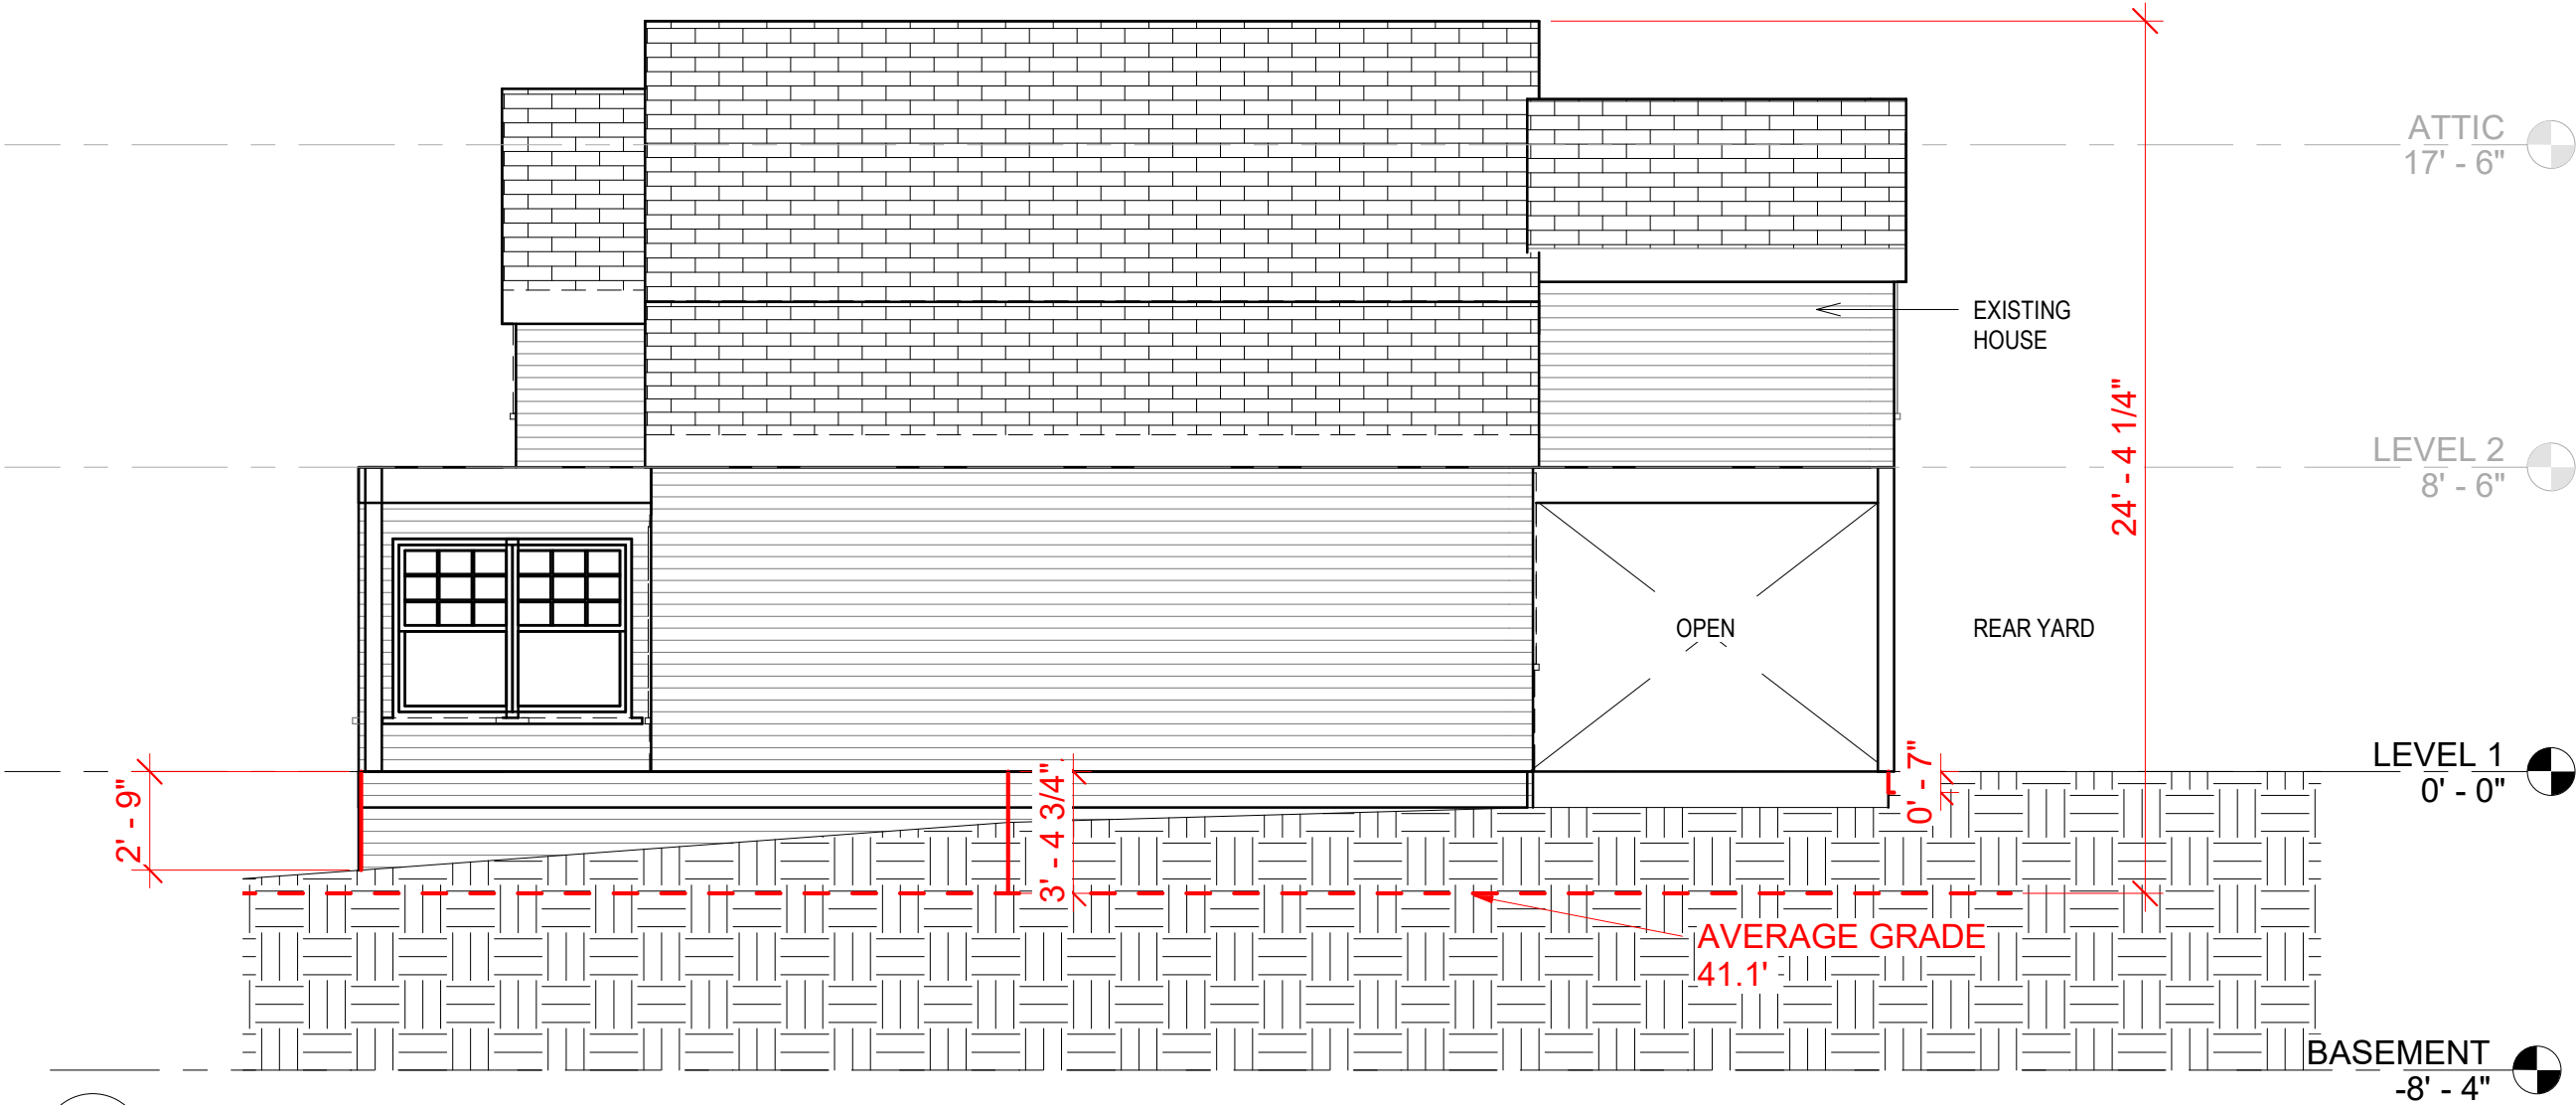

1 RIGHT ELEVATION - EXISTING  
A8 Scale: 3/16" = 1'-0"

GENERAL NOTE:  
CONTRACTOR TO FIELD VERIFY AND COORDINATE WITH OWNER FOR ALL CONSTRUCTION ISSUES.  
THIS DRAWING SET IS TO SHOW DESIGN INTENT AND FOR PERMIT APPLICATION ONLY.

FIRE ALARM LEGEND

- ③ SMOKE ALARM
- Ⓢ CO/SMOKE COMBO

LEGEND :

- EXISTING TO REMAIN
- DEMO
- NEW WORK



ARCHITECT:  
UP DESIGN & BUILD, LLC

EMAIL:  
INFO@UpDesignBuild.COM

PHONE:  
617-902 8626

PRELIMINARY CONCEPT,  
NOT VALID WITHOUT STAMP

180 PILGRIM RD

WEYMOUTH MA  
17' - 6"

RIGHT / WEST  
ELEVATION  
PROPOSED

LEVEL 2  
Project number 0.08


Date 03/22/2022

Drawn by Author

LEVEL 1  
Checked by U - U Checker

A8a

Scale As indicated

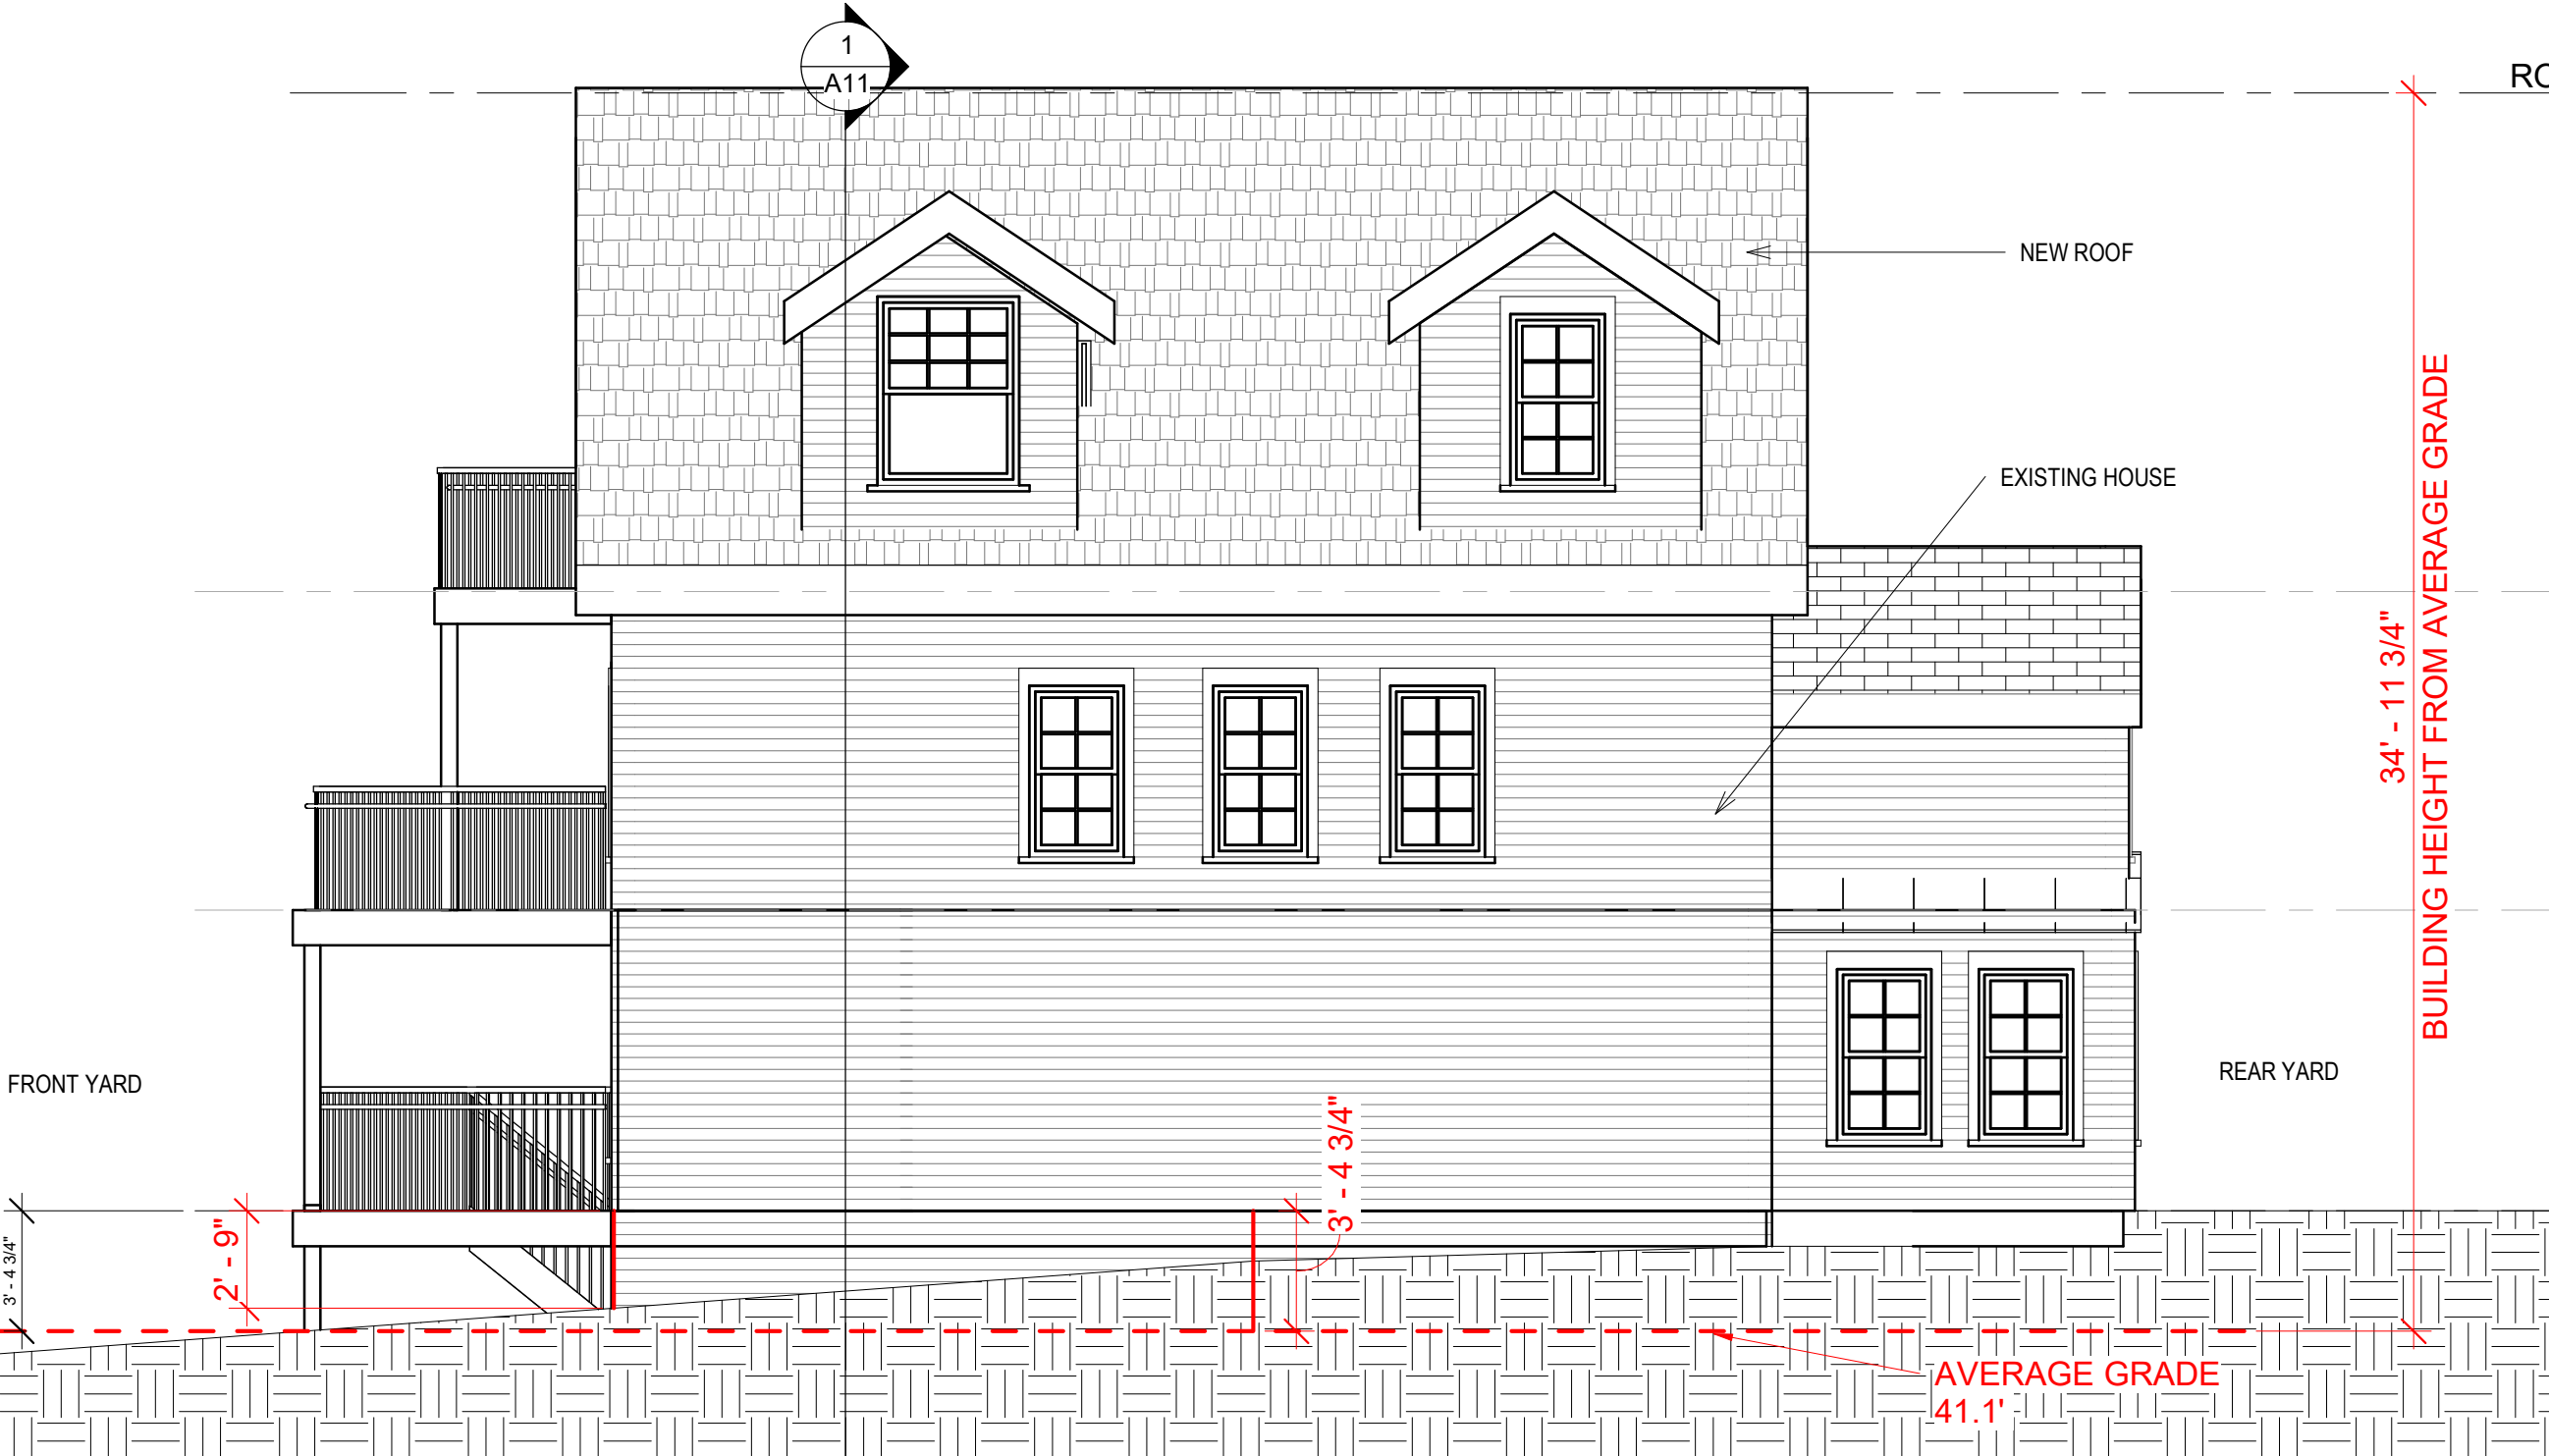


RIGHT ELEVATION - PROPOSED  
Scale: 3/16" = 1'-0"

GENERAL NOTE:  
CONTRACTOR TO FIELD VERIFY AND COORDINATE WITH OWNER FOR ALL CONSTRUCTION ISSUES.  
THIS DRAWING SET IS TO SHOW DESIGN INTENT AND FOR PERMIT APPLICATION ONLY.

FIRE ALARM LEGEND

Ⓢ SMOKE ALARM    Ⓢ/Ⓢ CO/SMOKE COMBO

LEGEND :

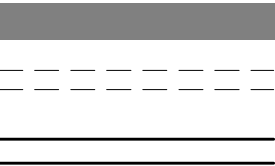

EXISTING TO REMAIN  
DEMO  
NEW WORK



ARCHITECT:  
UP DESIGN & BUILD, LLC

EMAIL:  
INFO@UpDesignBuild.COM

PHONE:  
617-902 8626

PRELIMINARY CONCEPT,  
NOT VALID WITHOUT STAMP

180 PILGRIM RD

WEYMOUTH MA

REAR  
ELEVATION  
EXISTING

Project number      0.08

Date                    03/22/2022

Drawn by             Author

Checked by          Checker

A9

Scale      As indicated




1 REAR ELEVATION EXISTING  
A9 Scale: 3/16" = 1'-0"

GENERAL NOTE:  
CONTRACTOR TO FIELD VERIFY AND COORDINATE WITH OWNER FOR ALL CONSTRUCTION ISSUES.  
THIS DRAWING SET IS TO SHOW DESIGN INTENT AND FOR PERMIT APPLICATION ONLY.

FIRE ALARM LEGEND

③ SMOKE ALARM    Ⓢ CO/SMOKE COMBO

LEGEND :

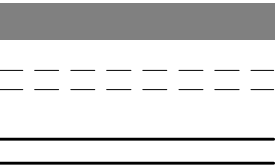

EXISTING TO REMAIN  
DEMO  
NEW WORK



ARCHITECT:  
UP DESIGN & BUILD, LLC

EMAIL:  
INFO@UpDesignBuild.COM

PHONE:  
617-902 8626

PRELIMINARY CONCEPT,  
NOT VALID WITHOUT STAMP

180 PILGRIM RD

WEYMOUTH MA

REAR  
ELEVATION -  
NEW

Project number      0.08


Date                    03/22/2022

Drawn by              Author

Checked by           Checker

A9a

Scale      As indicated

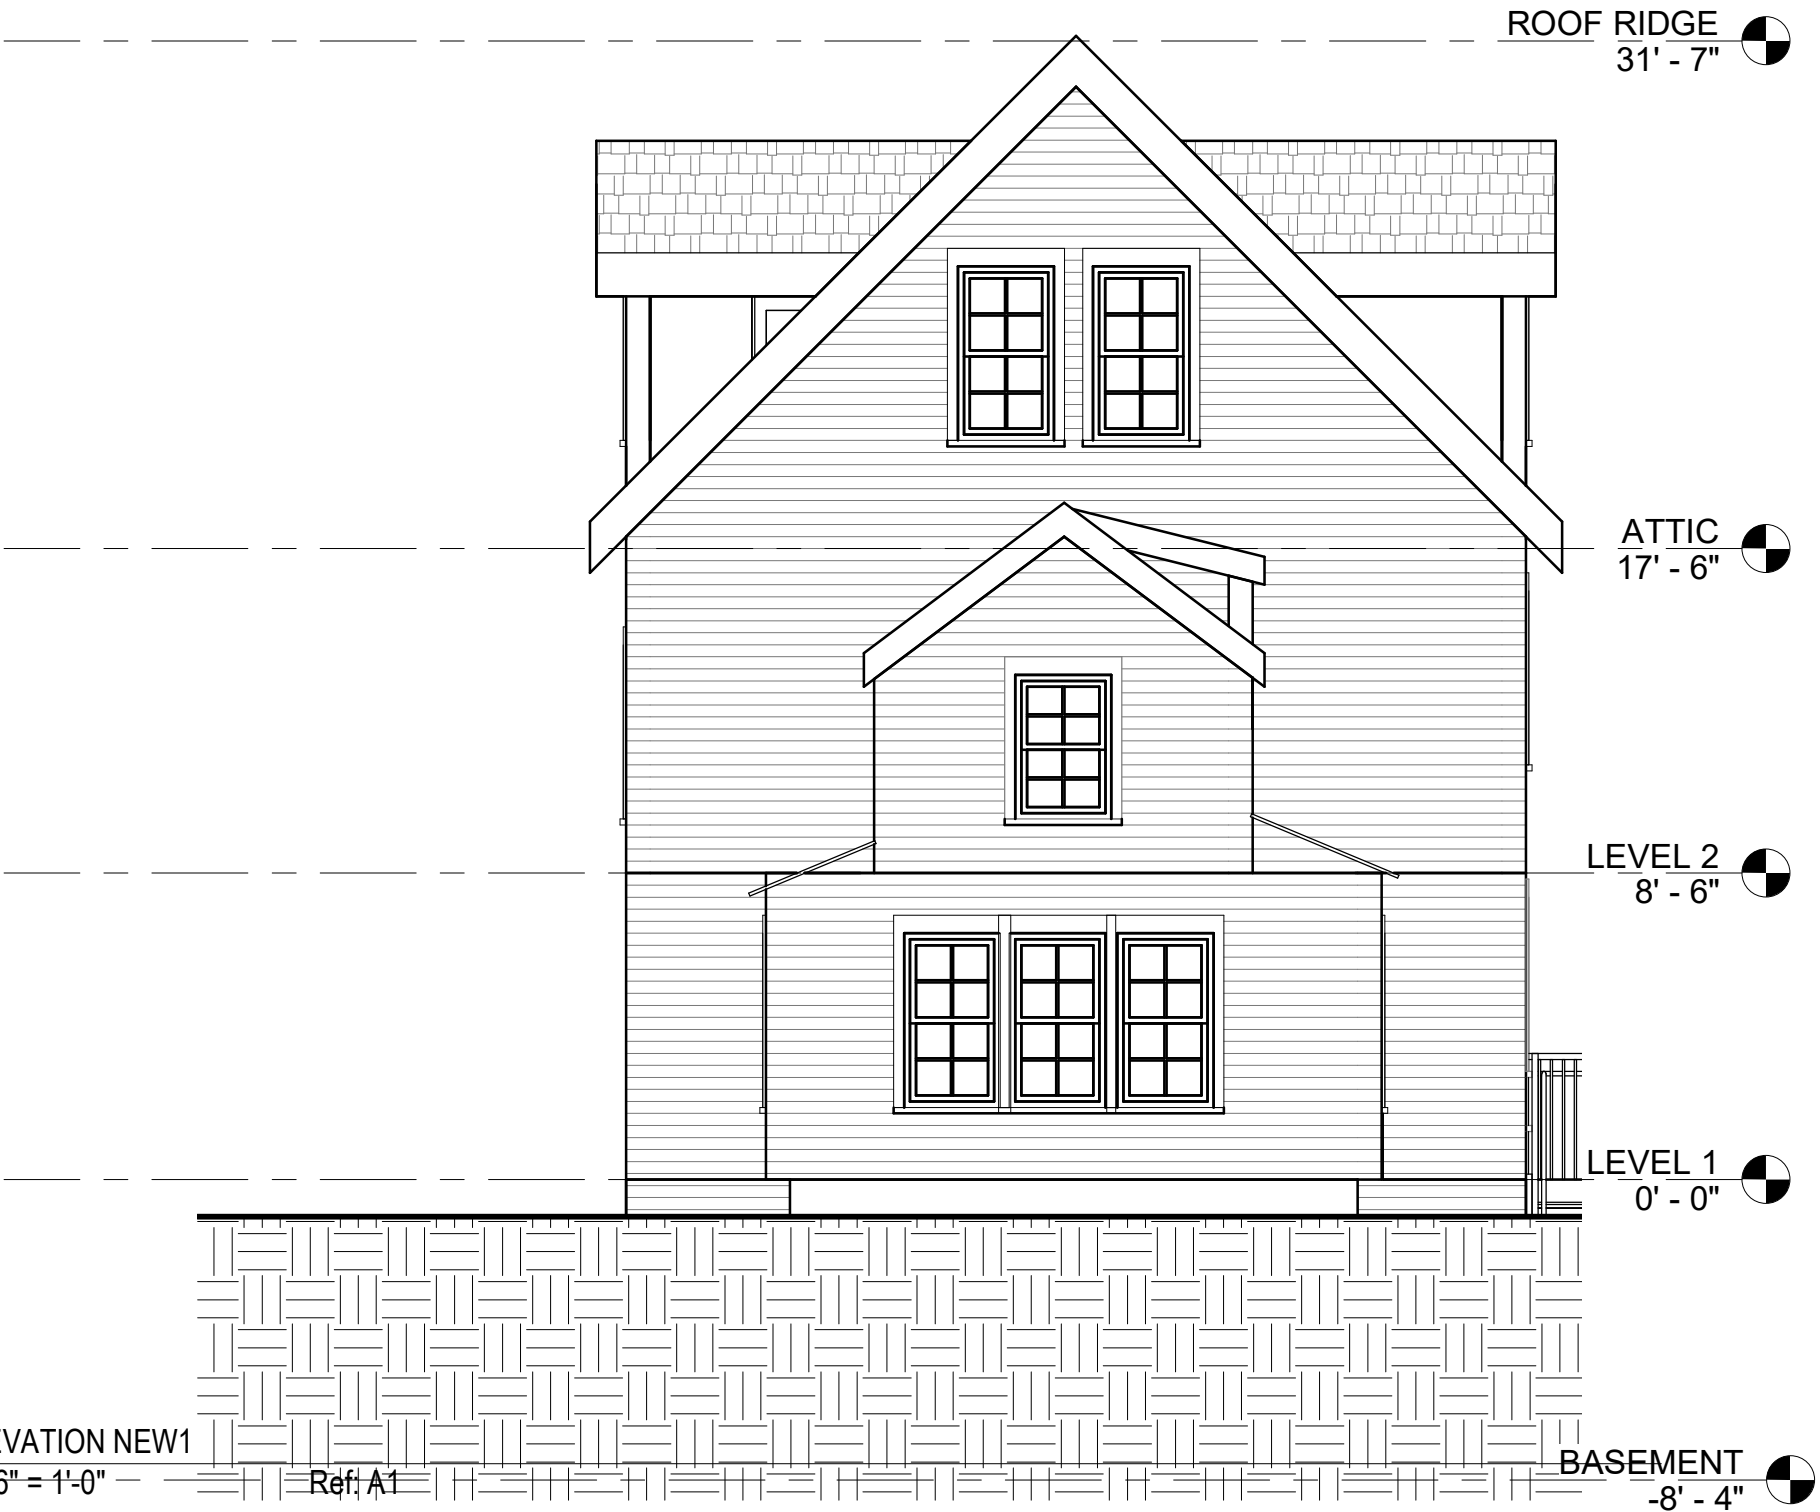

1 REAR ELEVATION NEW1  
A9a Scale: 3/16" = 1'-0"

Ref: A1


 
 


GENERAL NOTE:  
CONTRACTOR TO FIELD VERIFY AND COORDINATE WITH OWNER FOR ALL CONSTRUCTION ISSUES.  
THIS DRAWING SET IS TO SHOW DESIGN INTENT AND FOR PERMIT APPLICATION ONLY.

FIRE ALARM LEGEND

Ⓢ SMOKE ALARM    Ⓢ/Ⓢ CO/SMOKE COMBO

LEGEND :

 EXISTING TO REMAIN  
 DEMO  
 NEW WORK



ARCHITECT:  
UP DESIGN & BUILD, LLC

EMAIL:  
INFO@UpDesignBuild.COM

PHONE:  
617-902 8626

PRELIMINARY CONCEPT,  
NOT VALID WITHOUT STAMP

180 PILGRIM RD

WEYMOUTH MA

LEFT/ EAST  
ELEVATION  
EXISTING

Project number    0.08

Date    03/22/2022

Drawn by    Author

Checked by    Checker

A10

Scale    As indicated



1 LEFT/EAST ELEVATION - EXISTING  
A10 Scale: 3/16" = 1'-0"


GENERAL NOTE:  
CONTRACTOR TO FIELD VERIFY AND COORDINATE WITH OWNER FOR ALL CONSTRUCTION ISSUES.  
THIS DRAWING SET IS TO SHOW DESIGN INTENT AND FOR PERMIT APPLICATION ONLY.

FIRE ALARM LEGEND

- ⑤ SMOKE ALARM
- Ⓢ CO/SMOKE COMBO

LEGEND :

- EXISTING TO REMAIN
- DEMO
- NEW WORK

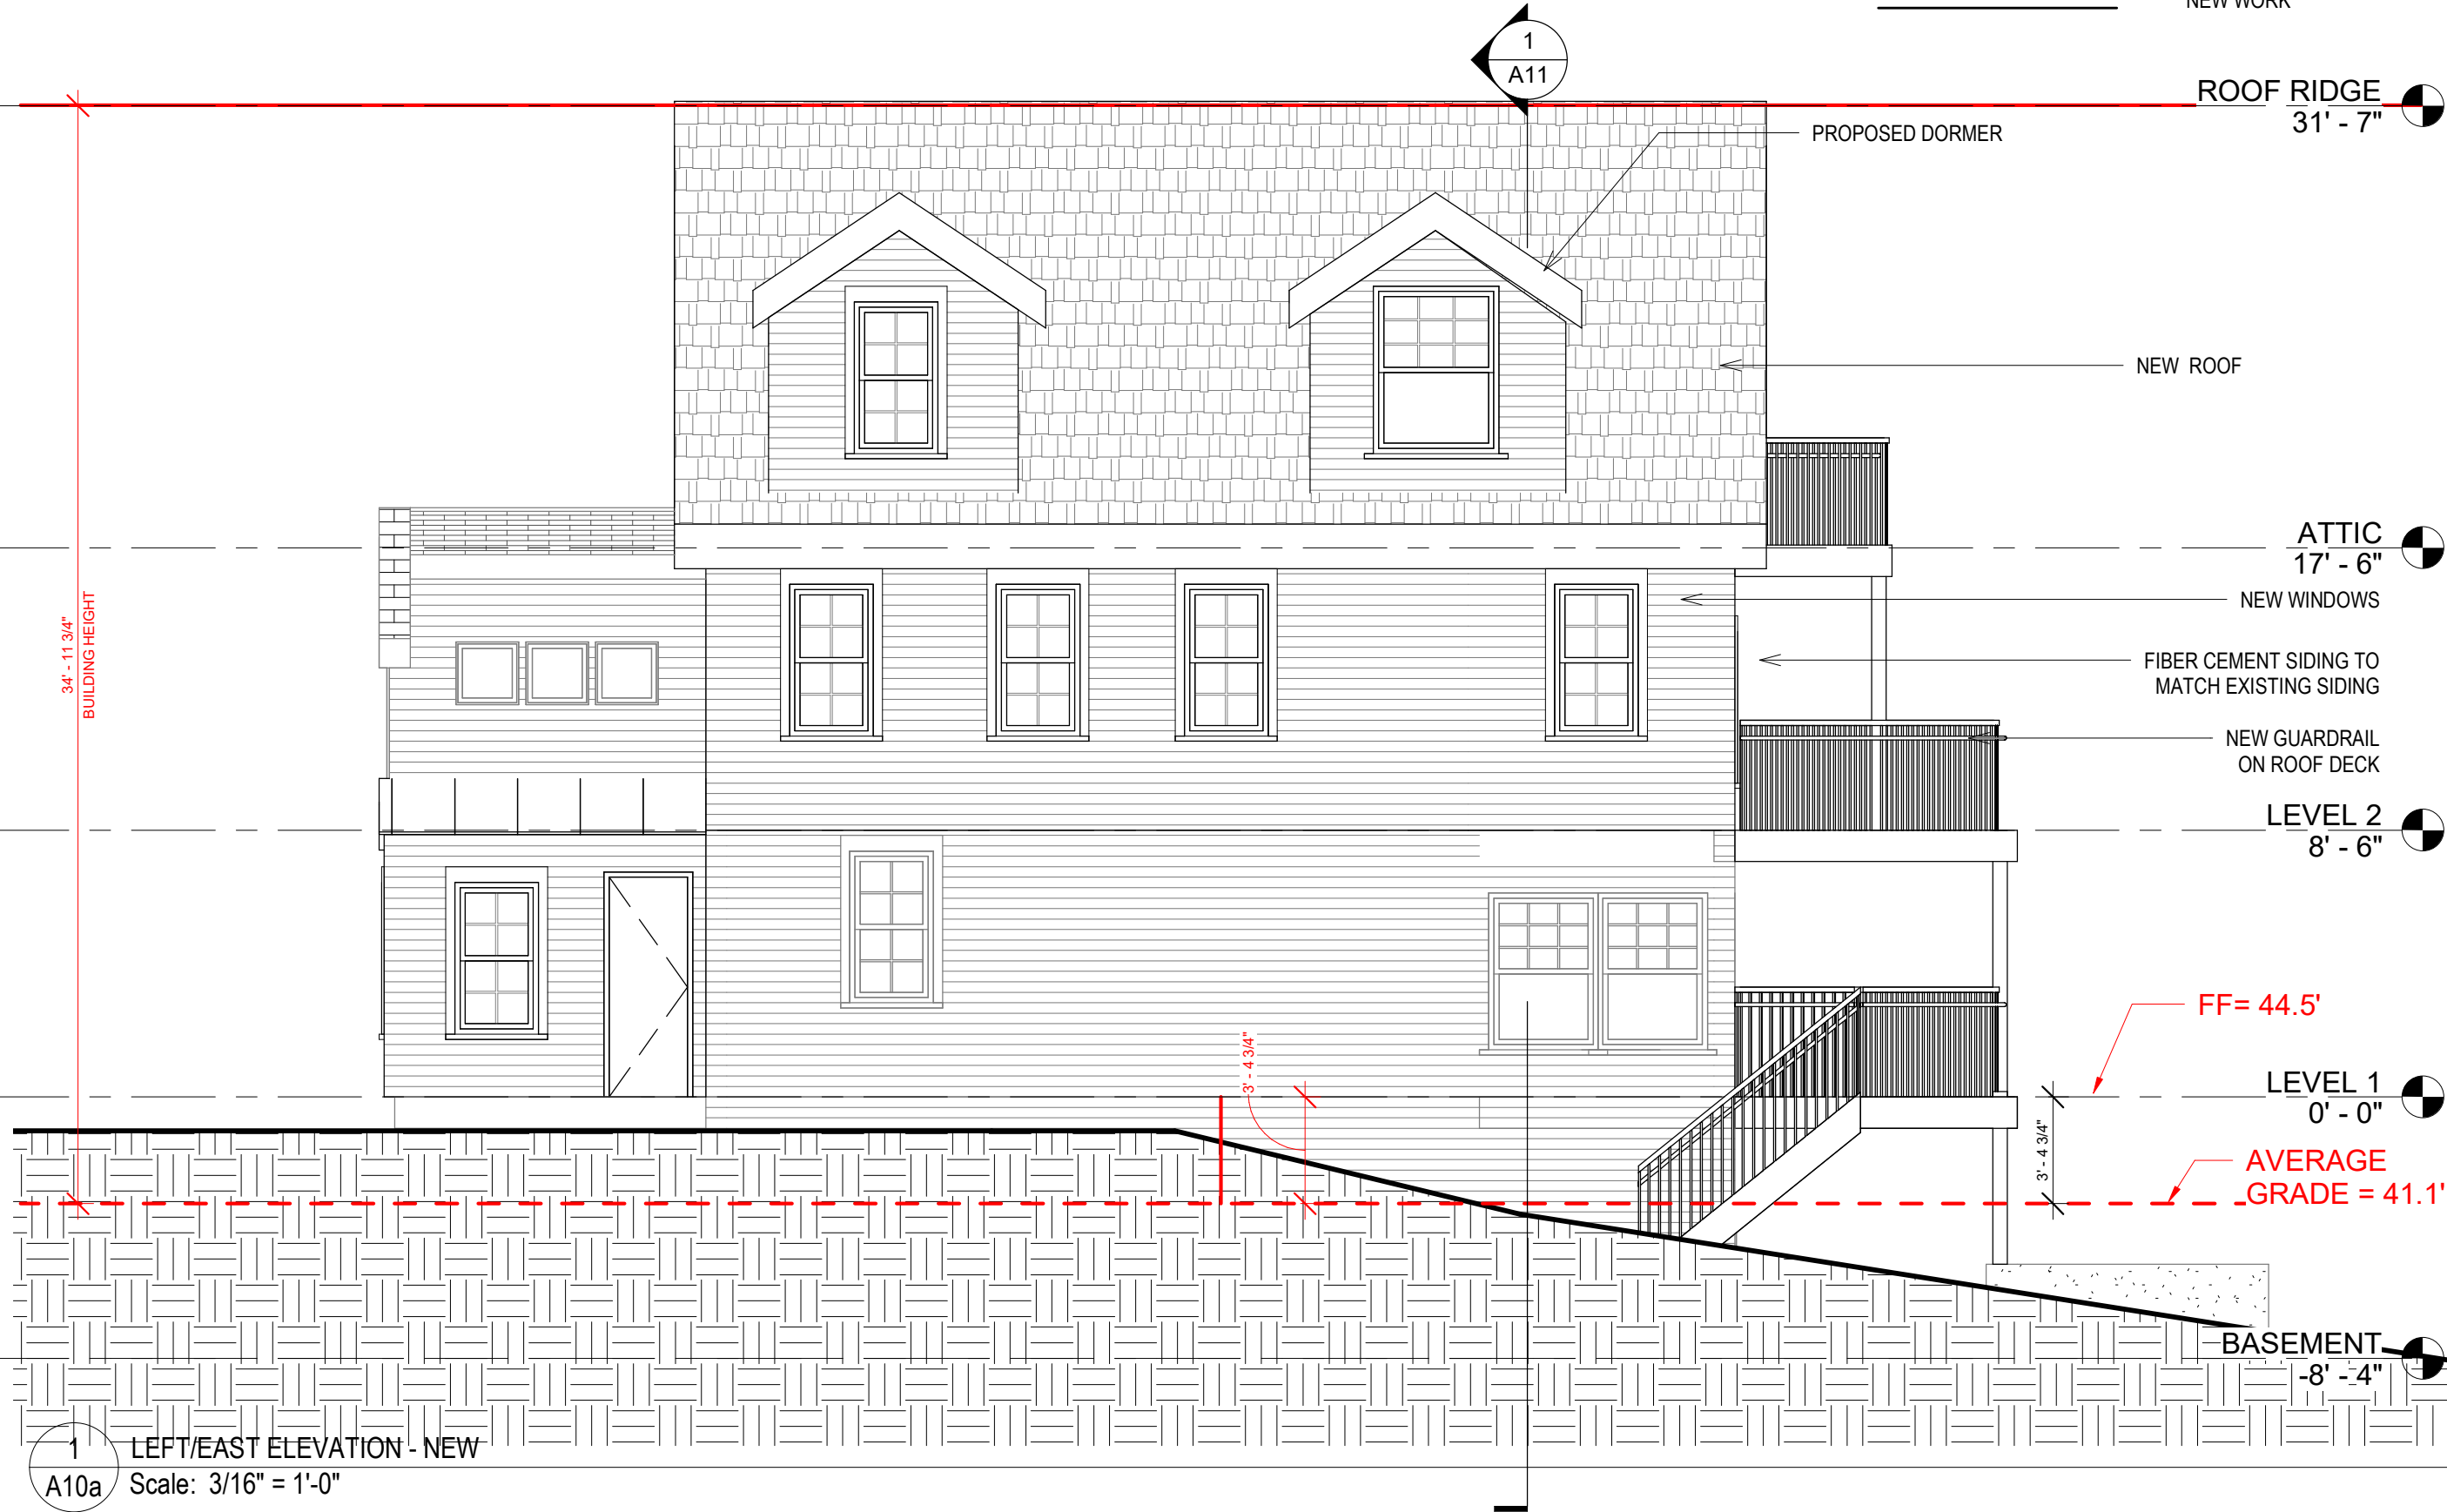

ARCHITECT:  
UP DESIGN & BUILD, LLC

EMAIL:  
INFO@UpDesignBuild.COM

PHONE:  
617-902 8626

PRELIMINARY CONCEPT,  
NOT VALID WITHOUT STAMP

180 PILGRIM RD

WEYMOUTH MA

LEFT/ EAST  
ELEVATION  
PROPOSED

Project number 0.08

Date 03/22/2022

Drawn by Author

Checked by Checker

A10a

Scale As indicated

3/22/2022 5:28:29 PM


GENERAL NOTE:  
CONTRACTOR TO FIELD VERIFY AND COORDINATE WITH OWNER FOR ALL CONSTRUCTION ISSUES.  
THIS DRAWING SET IS TO SHOW DESIGN INTENT AND FOR PERMIT APPLICATION ONLY.

FIRE ALARM LEGEND

- ⑤ SMOKE ALARM
- Ⓢ CO/SMOKE COMBO

LEGEND :

- EXISTING TO REMAIN
- DEMO
- NEW WORK

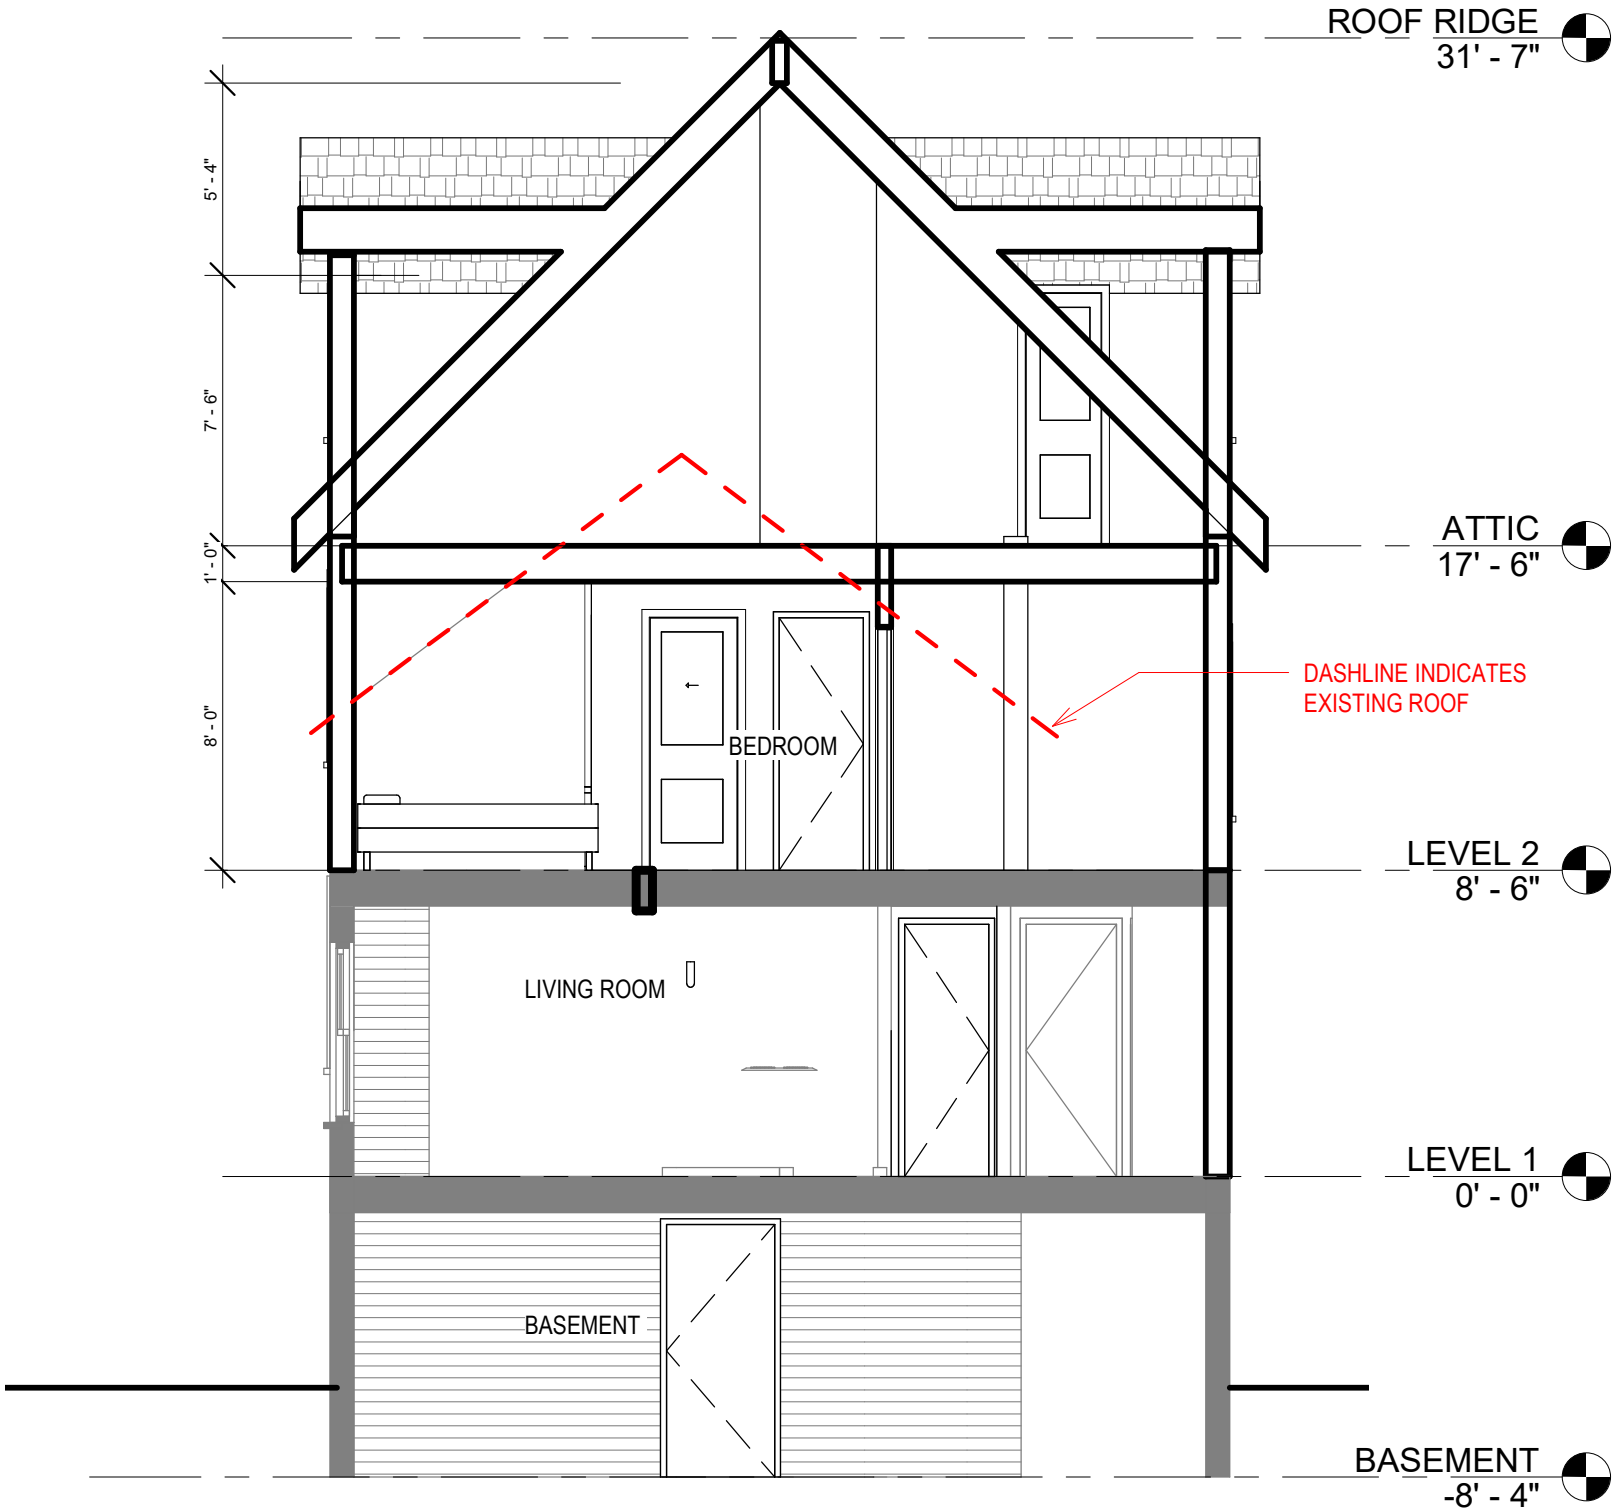

ARCHITECT:  
UP DESIGN & BUILD, LLC

EMAIL:  
INFO@UpDesignBuild.COM

PHONE:  
617-902 8626

PRELIMINARY CONCEPT,  
NOT VALID WITHOUT STAMP

180 PILGRIM RD

WEYMOUTH MA

SECTION 1

Project number 0.08

Date 03/22/2022

Drawn by Author

Checked by Checker

A11

Scale As indicated

1 Section 2  
A11 Scale: 3/16" = 1'-0"

Ref: A1

3/22/2022 5:28:29 PM





ARCHITECT:  
UP DESIGN & BUILD, LLC

EMAIL:  
INFO@UpDesignBuild.COM

PHONE:  
617-902 8626

PRELIMINARY CONCEPT,  
NOT VALID WITHOUT STAMP

180 PILGRIM RD

WEYMOUTH MA

3D VIEW

Project number 0.08

Date 03/22/2022

Drawn by Author

Checked by Checker

A12

Scale

PROPOSED DORMER

PROPOSED DORMER

