



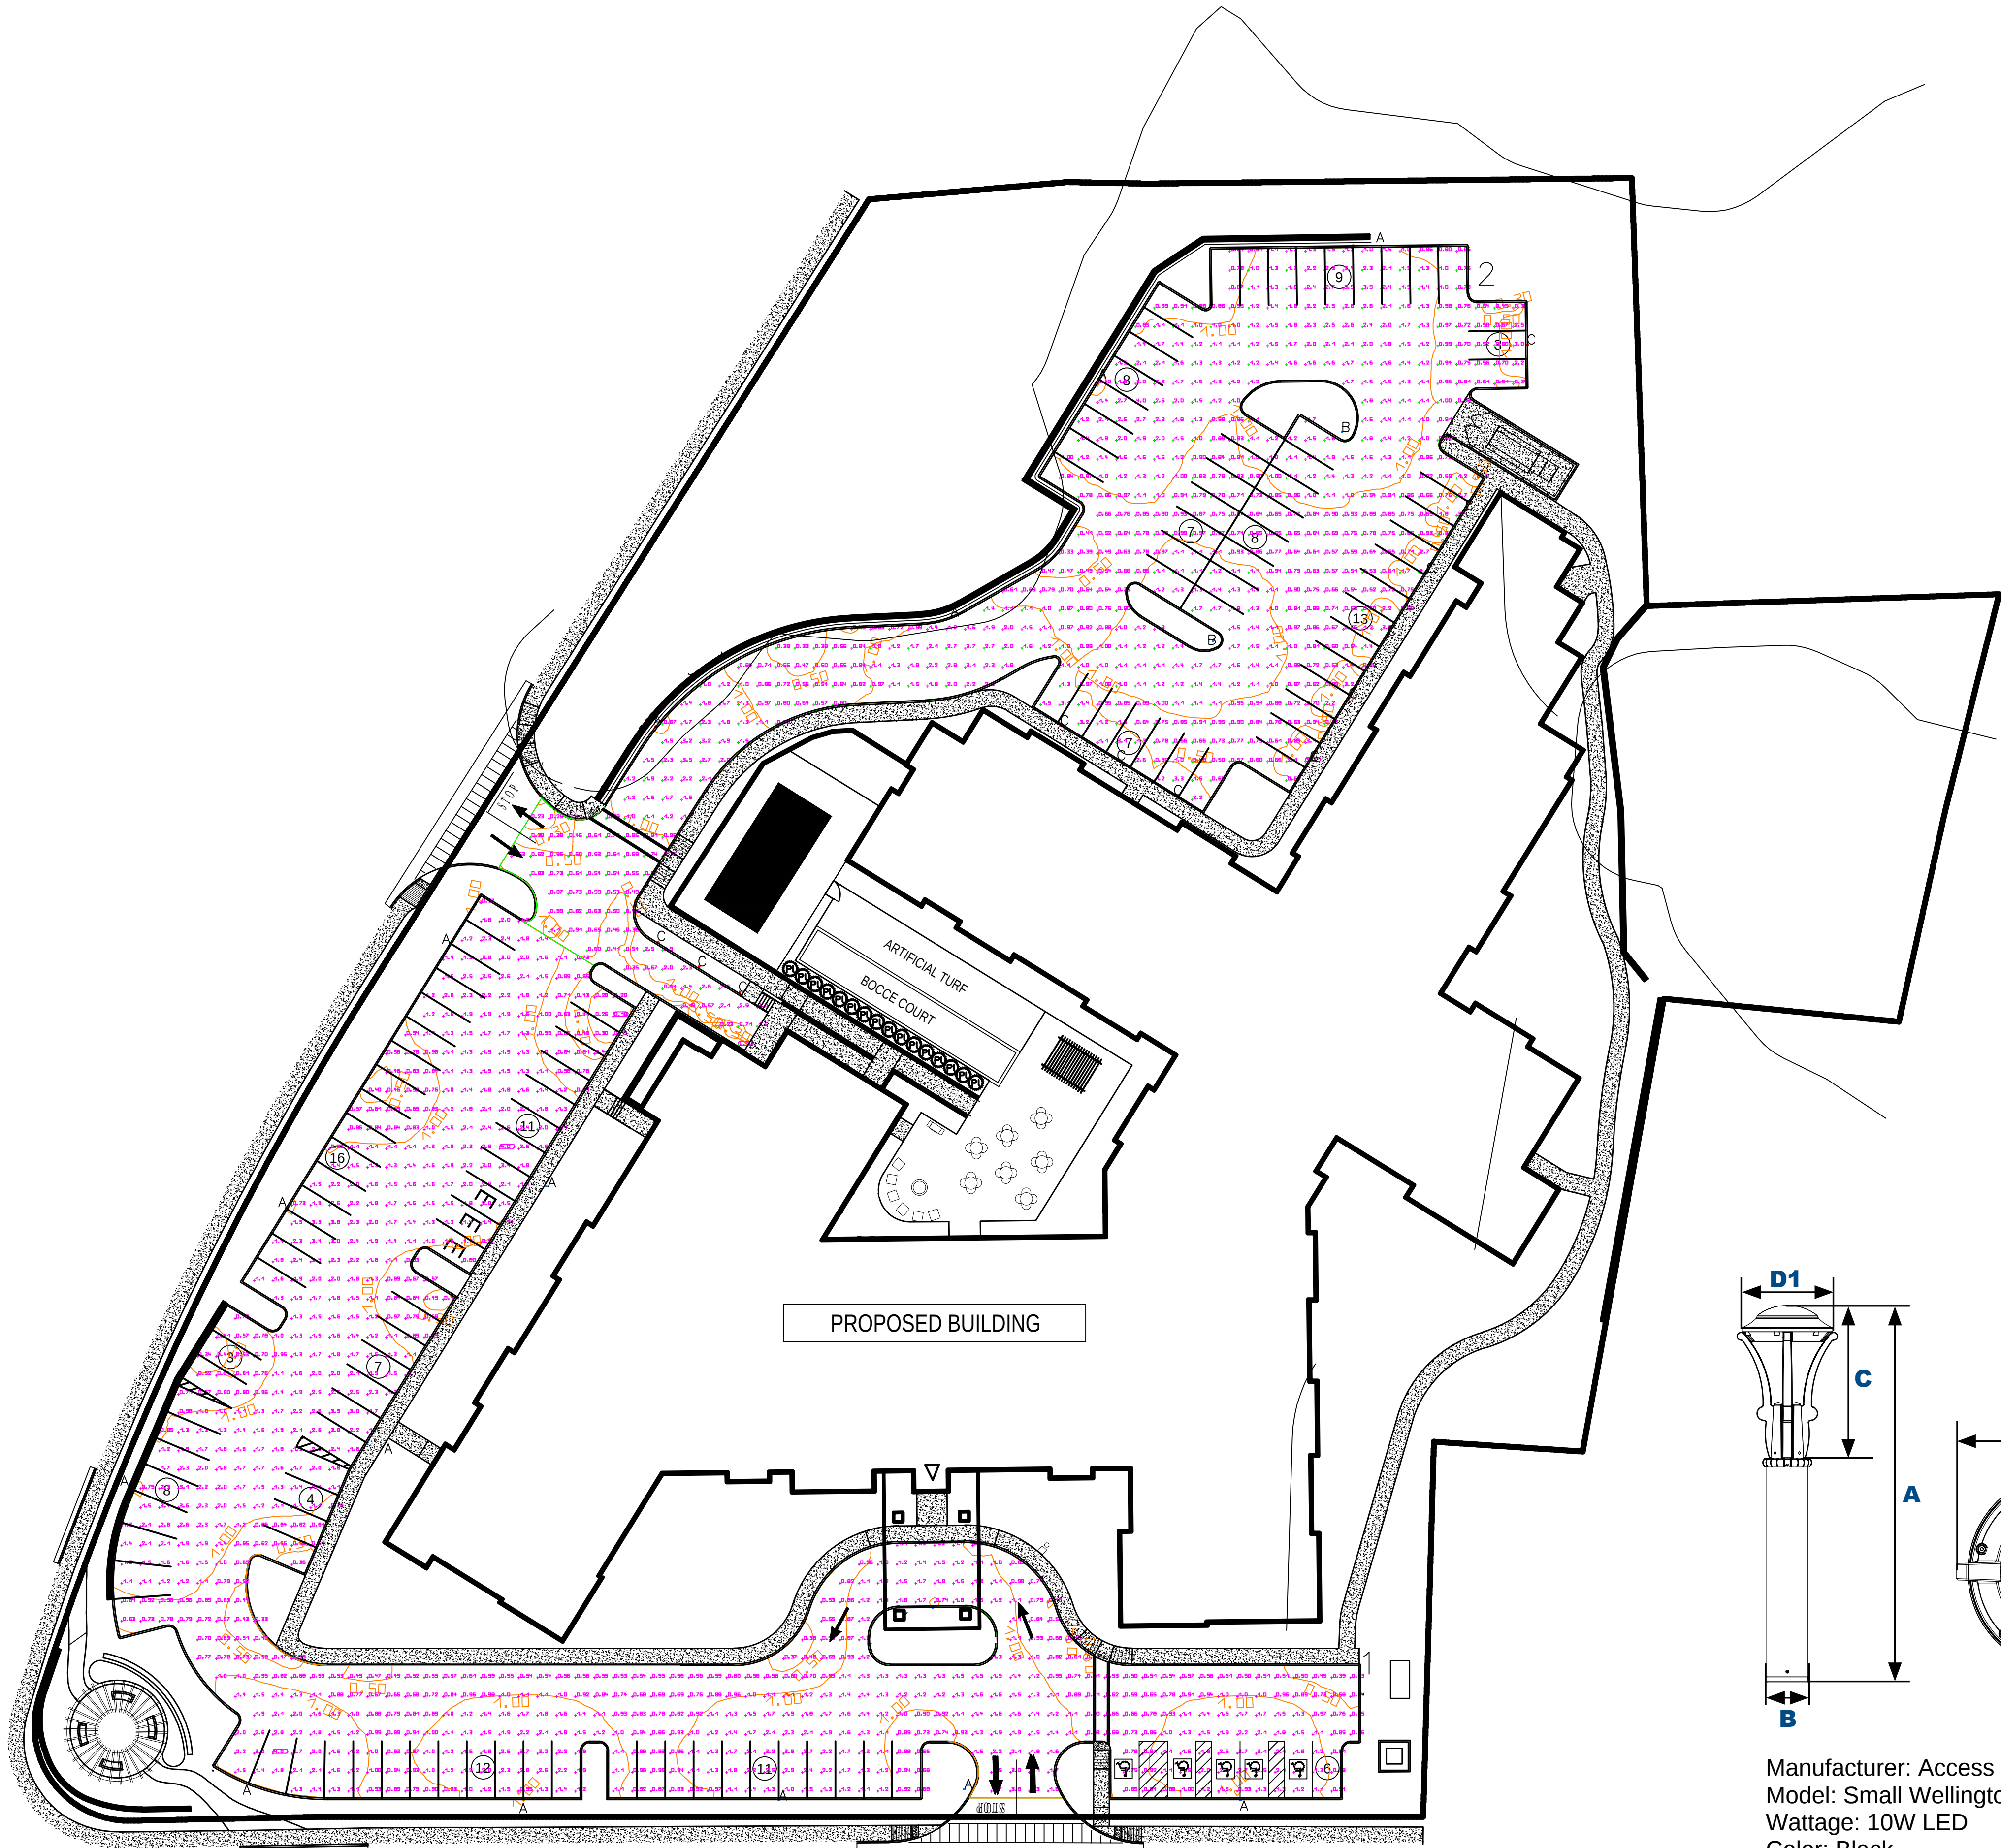

Luminaire List								
Index	Manufacturer	Article name	Item number	Luminous flux	Light loss factor	Connected load	Quantity	Mounting Height
A	Access Fixtures	WM21Q WITH ONE 65W LED ARRAY, TYPE IV, CLEAR LENS	WM21QD1X65U3KC	7005 lm	0.80	71.3 W	14	15'-0"
B	Access Fixtures	WM21Q WITH ONE 65W LED ARRAY, TYPE V, CLEAR LENS	WM21QF1X65U3KC	7111 lm	0.80	71.3 W	3	15'-0"
C	Access Fixtures	WMB12QF WITH ONE 10W LED ARRAY, TYPE V, CLEAR LENS	WMB12QF1X10U3K	918 lm	0.80	10.3 W	12	3'-6"



#	Name	Parameter	Min	Max	Average	Mean/Min	Max/Min
1	1st Entrance Area	Perpendicular illuminance	0.18 fc	3.99 fc	1.34 fc	7.46	22.23
2	2nd Entrance Area	Perpendicular illuminance	0.10 fc	5.35 fc	1.22 fc	11.63	50.95

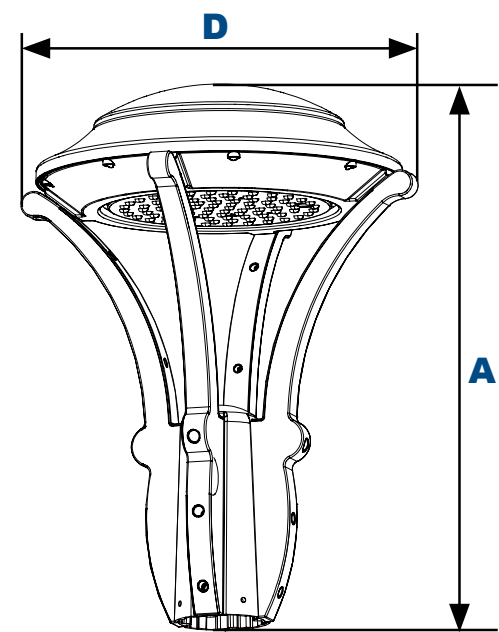

Dimensions	
Diameter (D)	21" (534mm)
Height (A)	27¾" (705mm)

Manufacturer: Access Fixtures
Model: Wellington Architectural Decorative Post Top
Wattage: 65W LED Light Color: 3000K
Color: Black
Post Height: 15' Material: Aluminum


A and B Fixtures

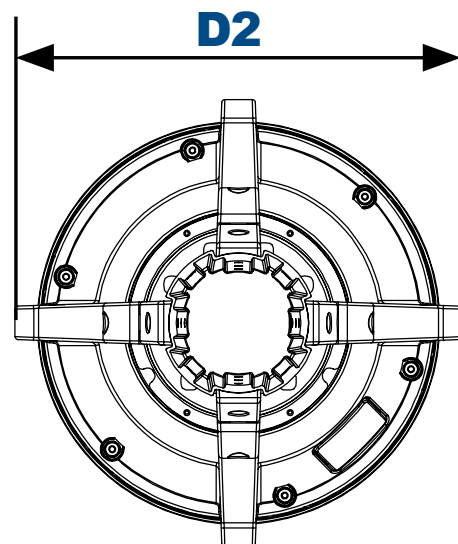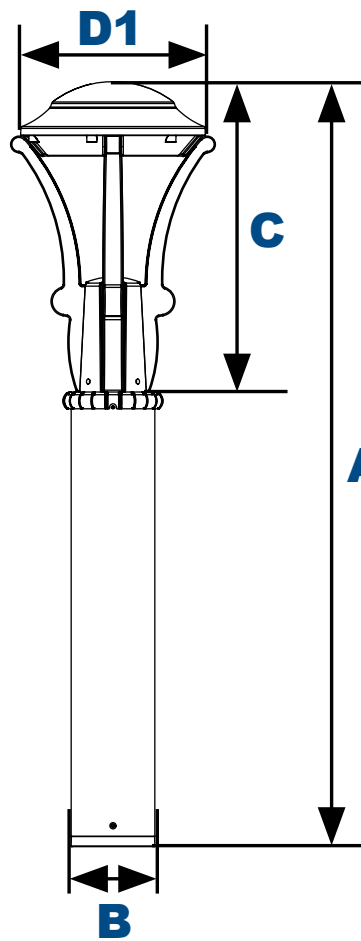

Dimensions	
Diameter 1 (D1)	10½" (264mm)
Diameter 2 (D2)	11½" (294mm)
Height 1 (A)	43" (1093mm)
Height 2 (C)	17¾" (441mm)
Base (B)	4¾" (120mm)

Manufacturer: Access Fixtures
Model: Small Wellington Bollard
Wattage: 10W LED
Color: Black

Bollard Light Fixtures

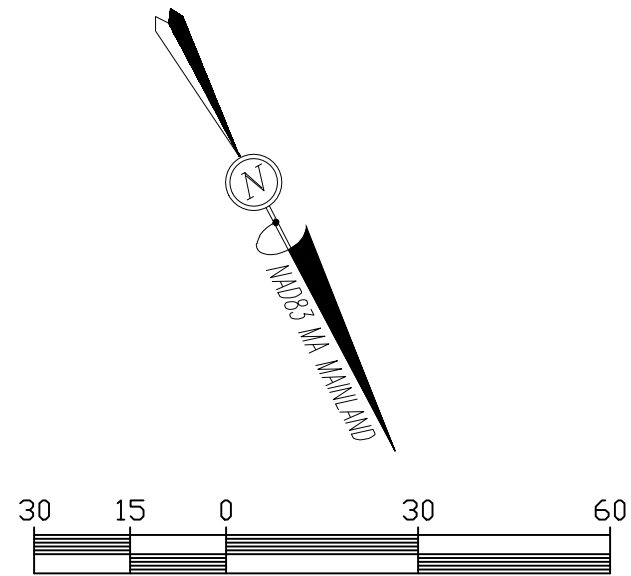

Date	Description	No.
Revisions		



LONGSTONE GARDENS
1905 MILLERSVILLE PIKE LANCASTER, PA 17603
P) (267)664-6336 F) (717)884-6682
EMAIL: JLDDESIGNS@COMCAST.NET

Project
CORNERSTONE AT WEYMOUTH

Prepared for
ELKSY DEVELOPMENT LLC
#180 CANTON AVENUE
MILTON, MA 02186

Drawing Title
LIGHTING PLAN

Project No.	Drawing No.
Date 07 - 01 - 2022	LA-2
Scale 1" = 30'	
Drawn By JLL	
Approved By JLL	