


nationalgrid

LOCATION MAP:

SCALE: NOT TO SCALE

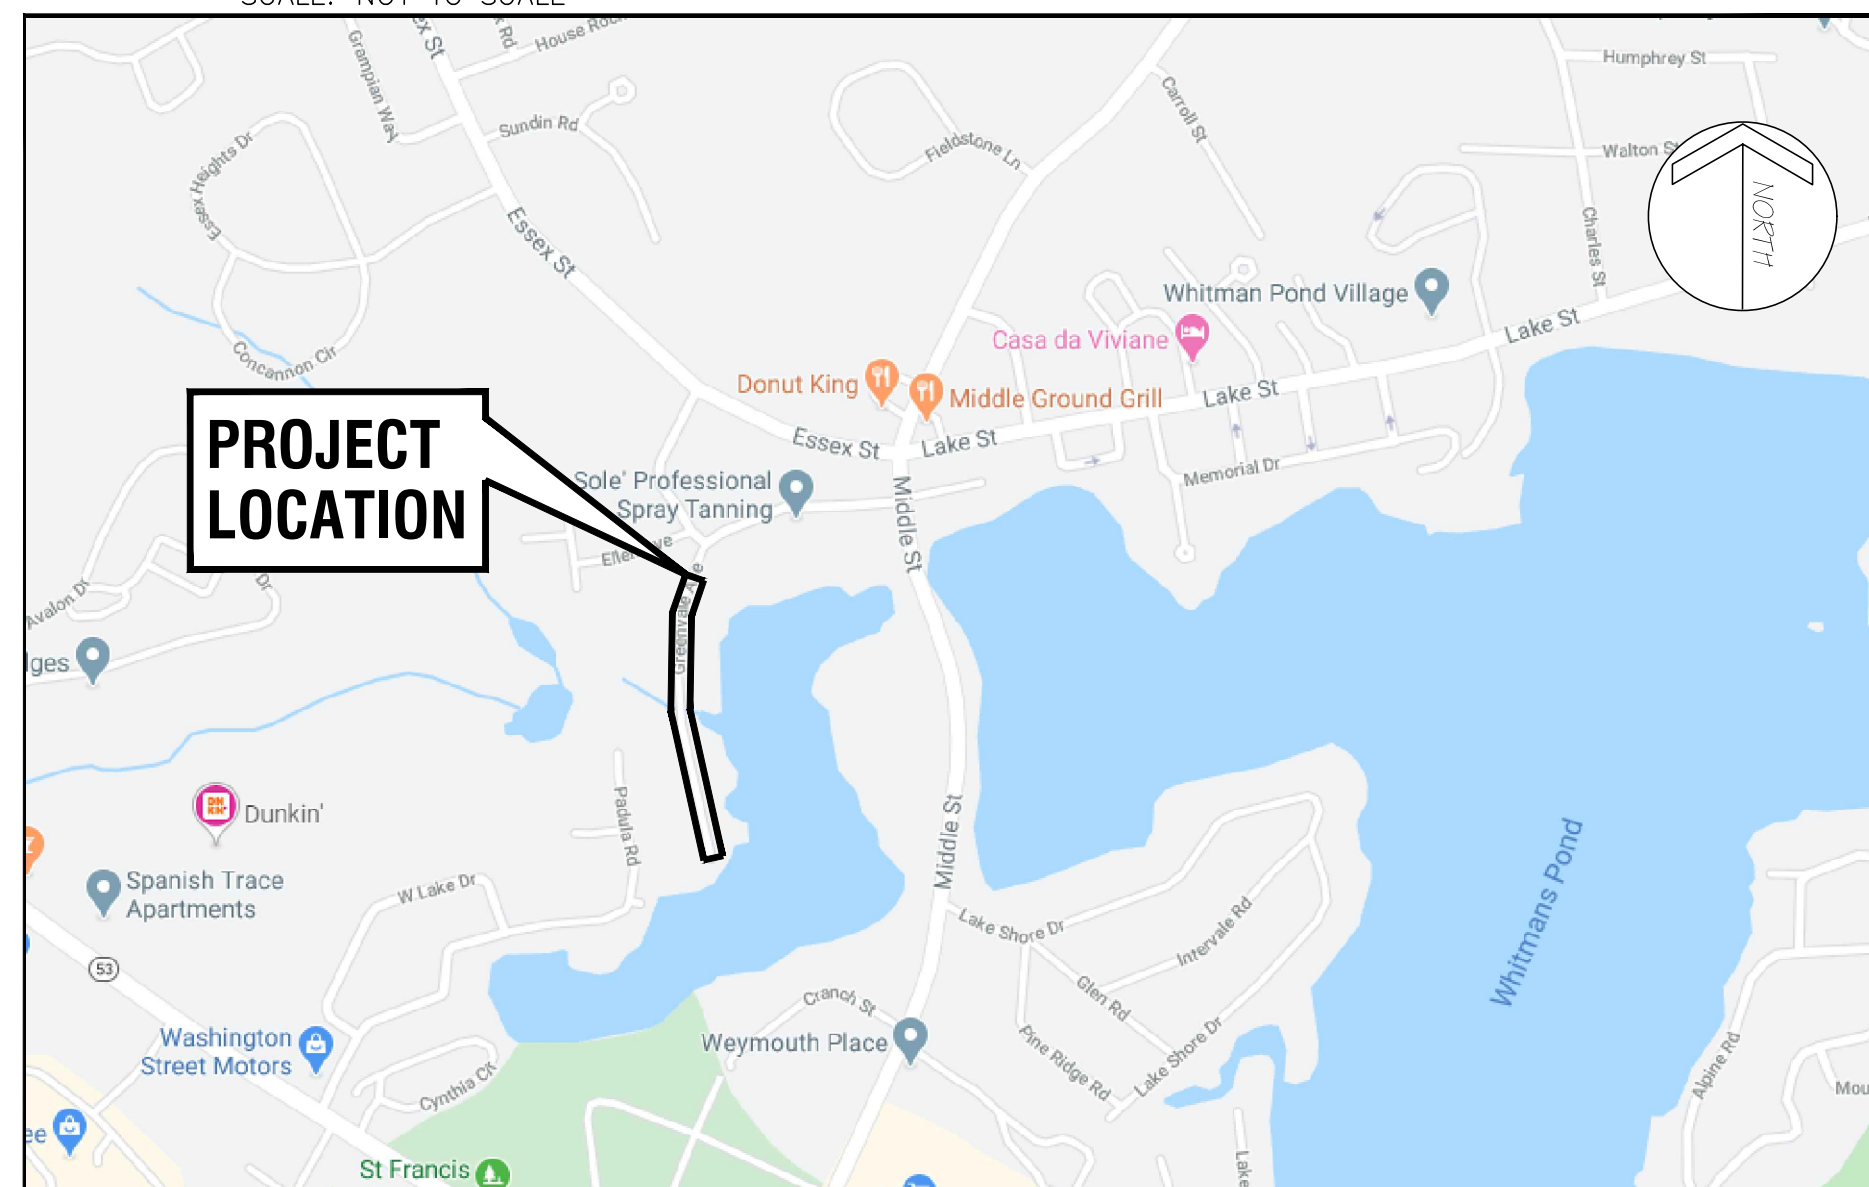

TOTAL WORK QUANTITIES


TOTAL PIPE INSTALLATION	ESTIMATED	ACTUAL
2" HDPE	260'	
TOTAL TRENCH BACKFILL		
TOTAL ASPHALT & CONCRETE BREAKS		

DRAWING INDEX

DRAWING NO.	DRAWING TITLE
T-001	TITLE SHEET
G-001	NOTES & LEGEND
G-002	BILL OF MATERIALS
C-001	EXISTING CONDITIONS
C-101	PROPOSED HDD PLAN AND PROFILE
M-001	TIE-IN DETAILS





ISSUED FOR CONSTRUCTION
OCTOBER 2020

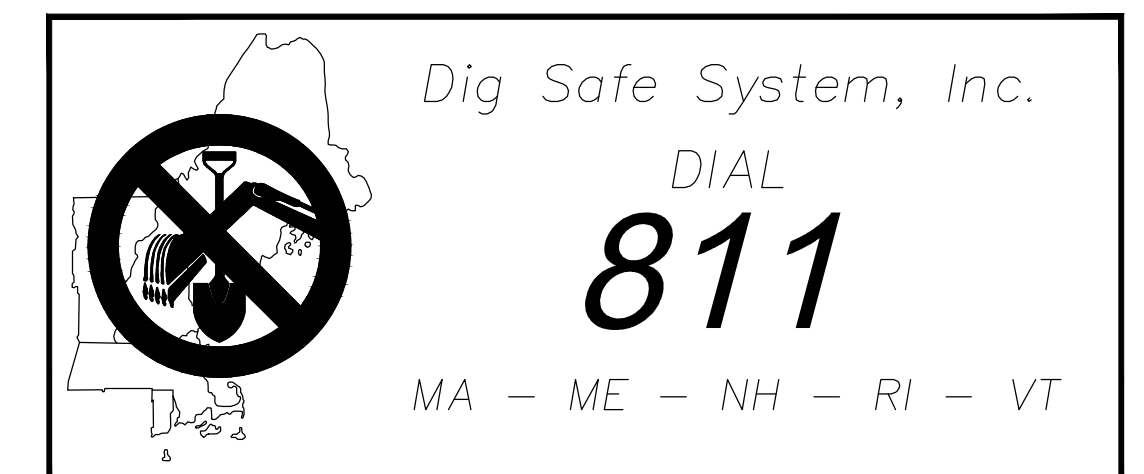[illegible]


NOTE: ALL MATERIAL QUANTITIES ARE ESTIMATED BASED ON PROPOSED DESIGN. ADDITIONAL QUANTITIES AND/OR OTHER MATERIALS MAY BE REQUIRED TO CONSTRUCT VERTICAL OFFSETS OR DUE TO OTHER UNKNOWN AS-FOUND CONDITIONS/DESIGN CONFLICTS AND FOR TESTING.

File: V:\PROJECTS\ANY\VS 058260.000\CADD\ACAD\CIVL 058260.DWG
Saved: 9/17/2020 4:35:19 PM Plotted: 10/17/2020 11:28:20 AM User: Stevens, Alex LastSavedBy: 5805

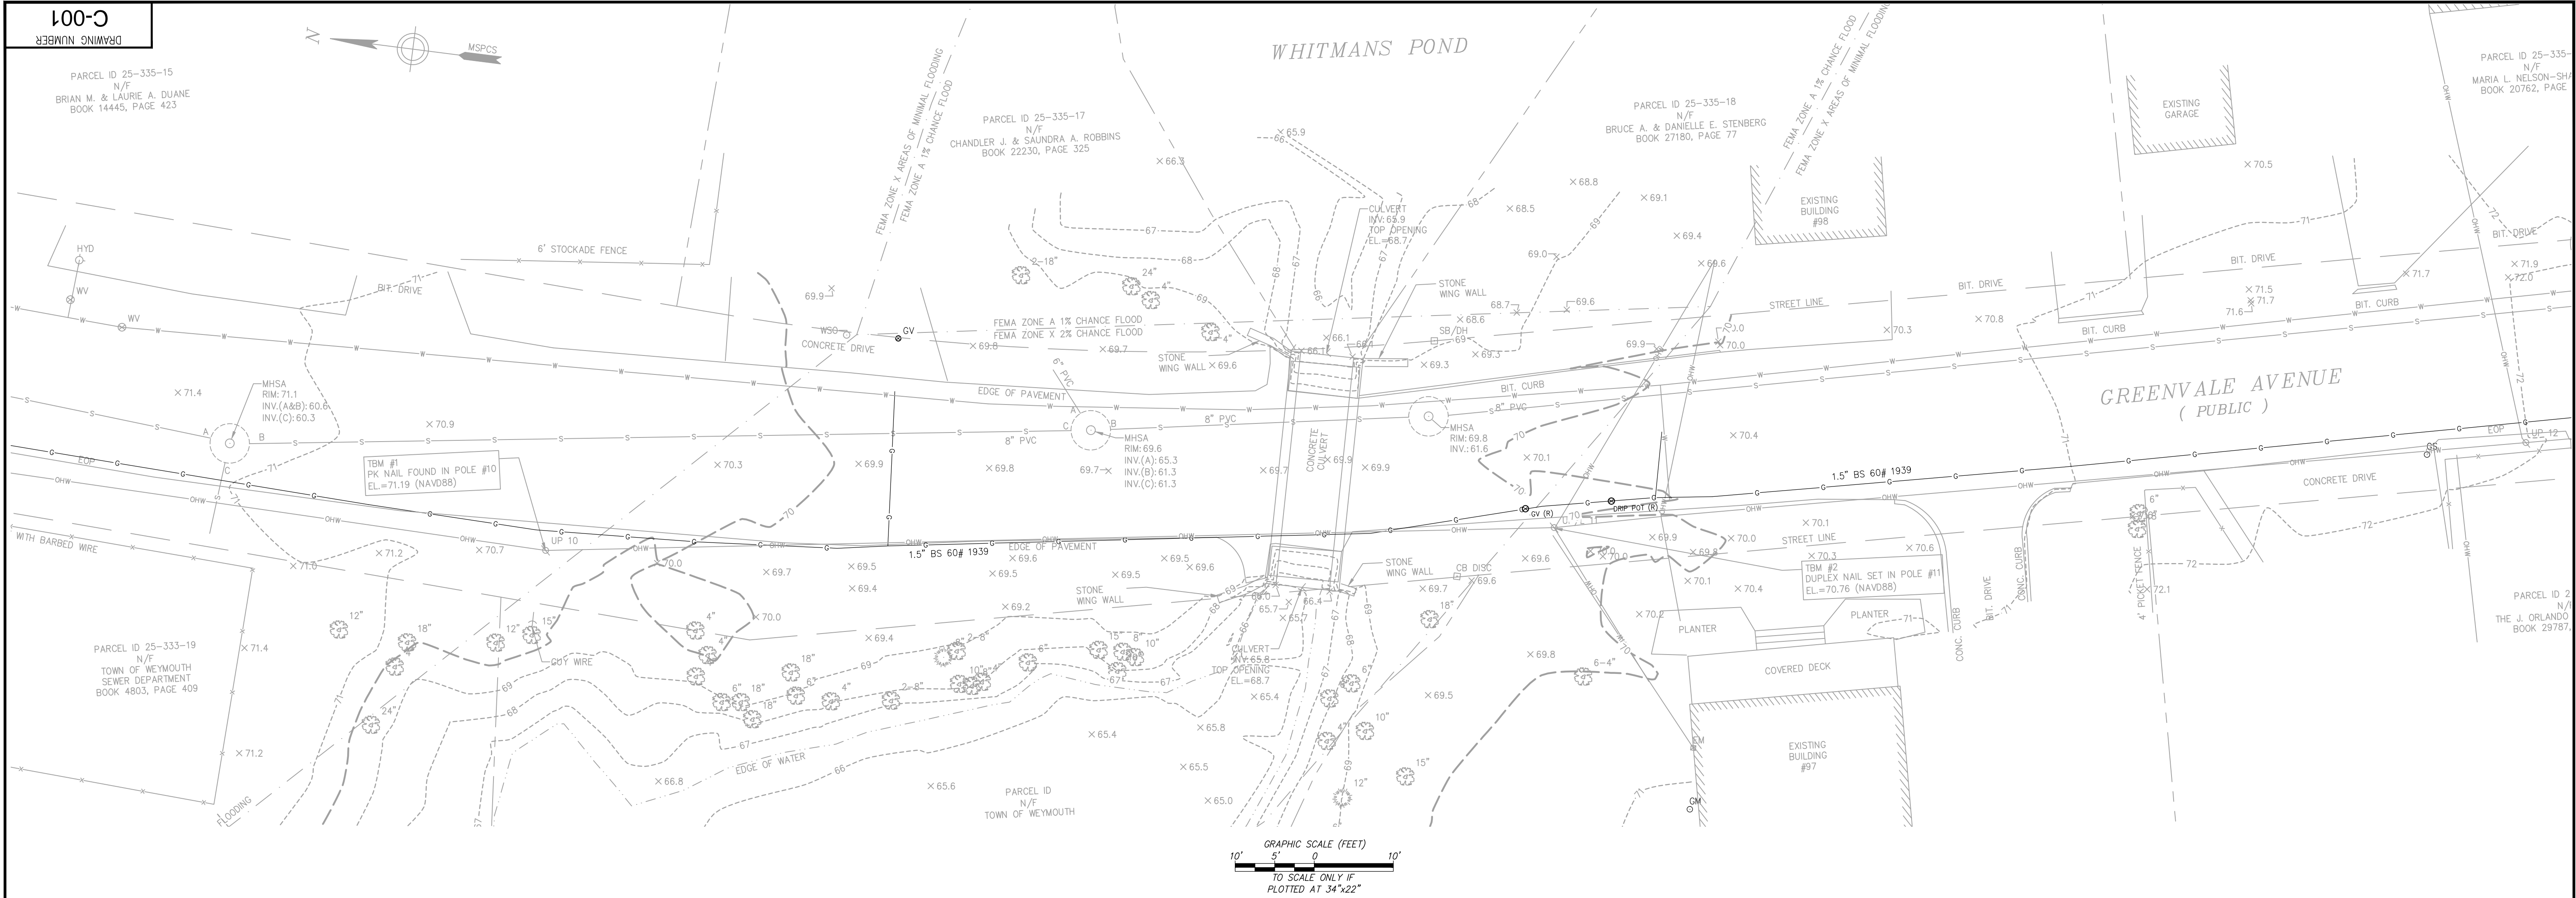


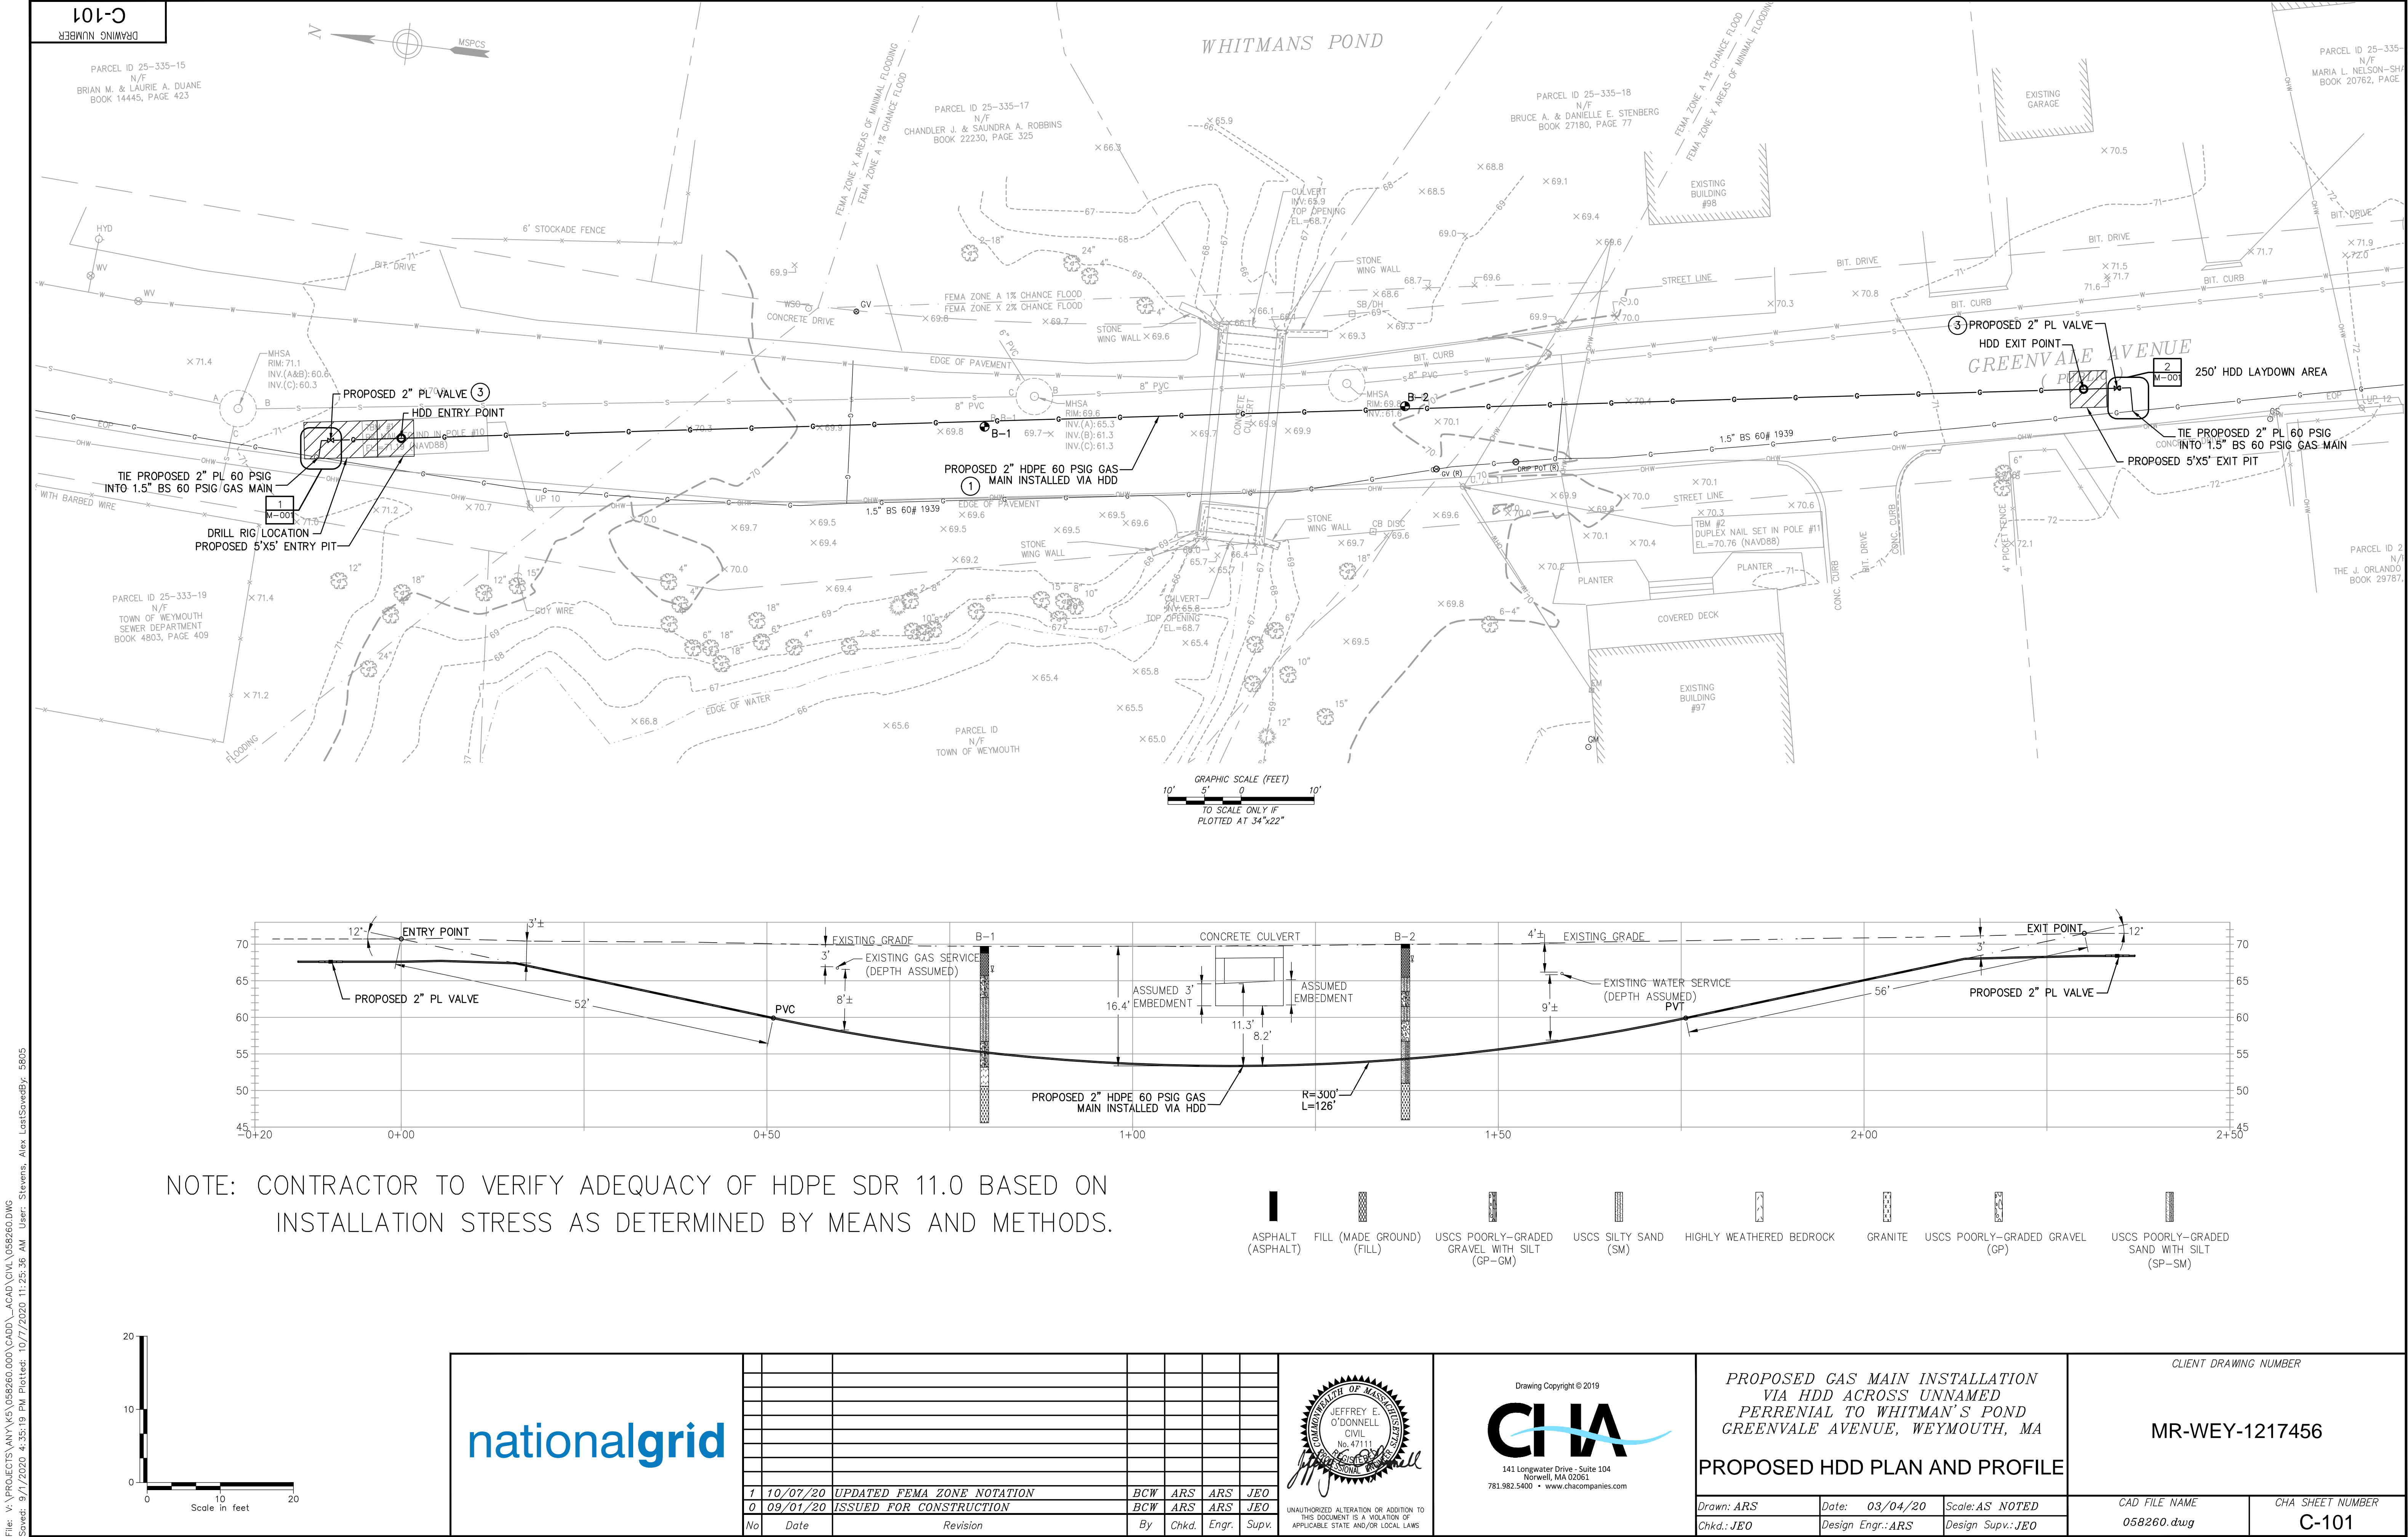

File: V:\PROJECTS\ANY\VS 058260.dwg\CAED\CAED\CIVIL 058260.dwg
Saved: 9/1/2020 4:35:19 PM Plotted: 10/17/2020 11:25:36 AM User: Stevens, Alex LastSavedBy: 5805

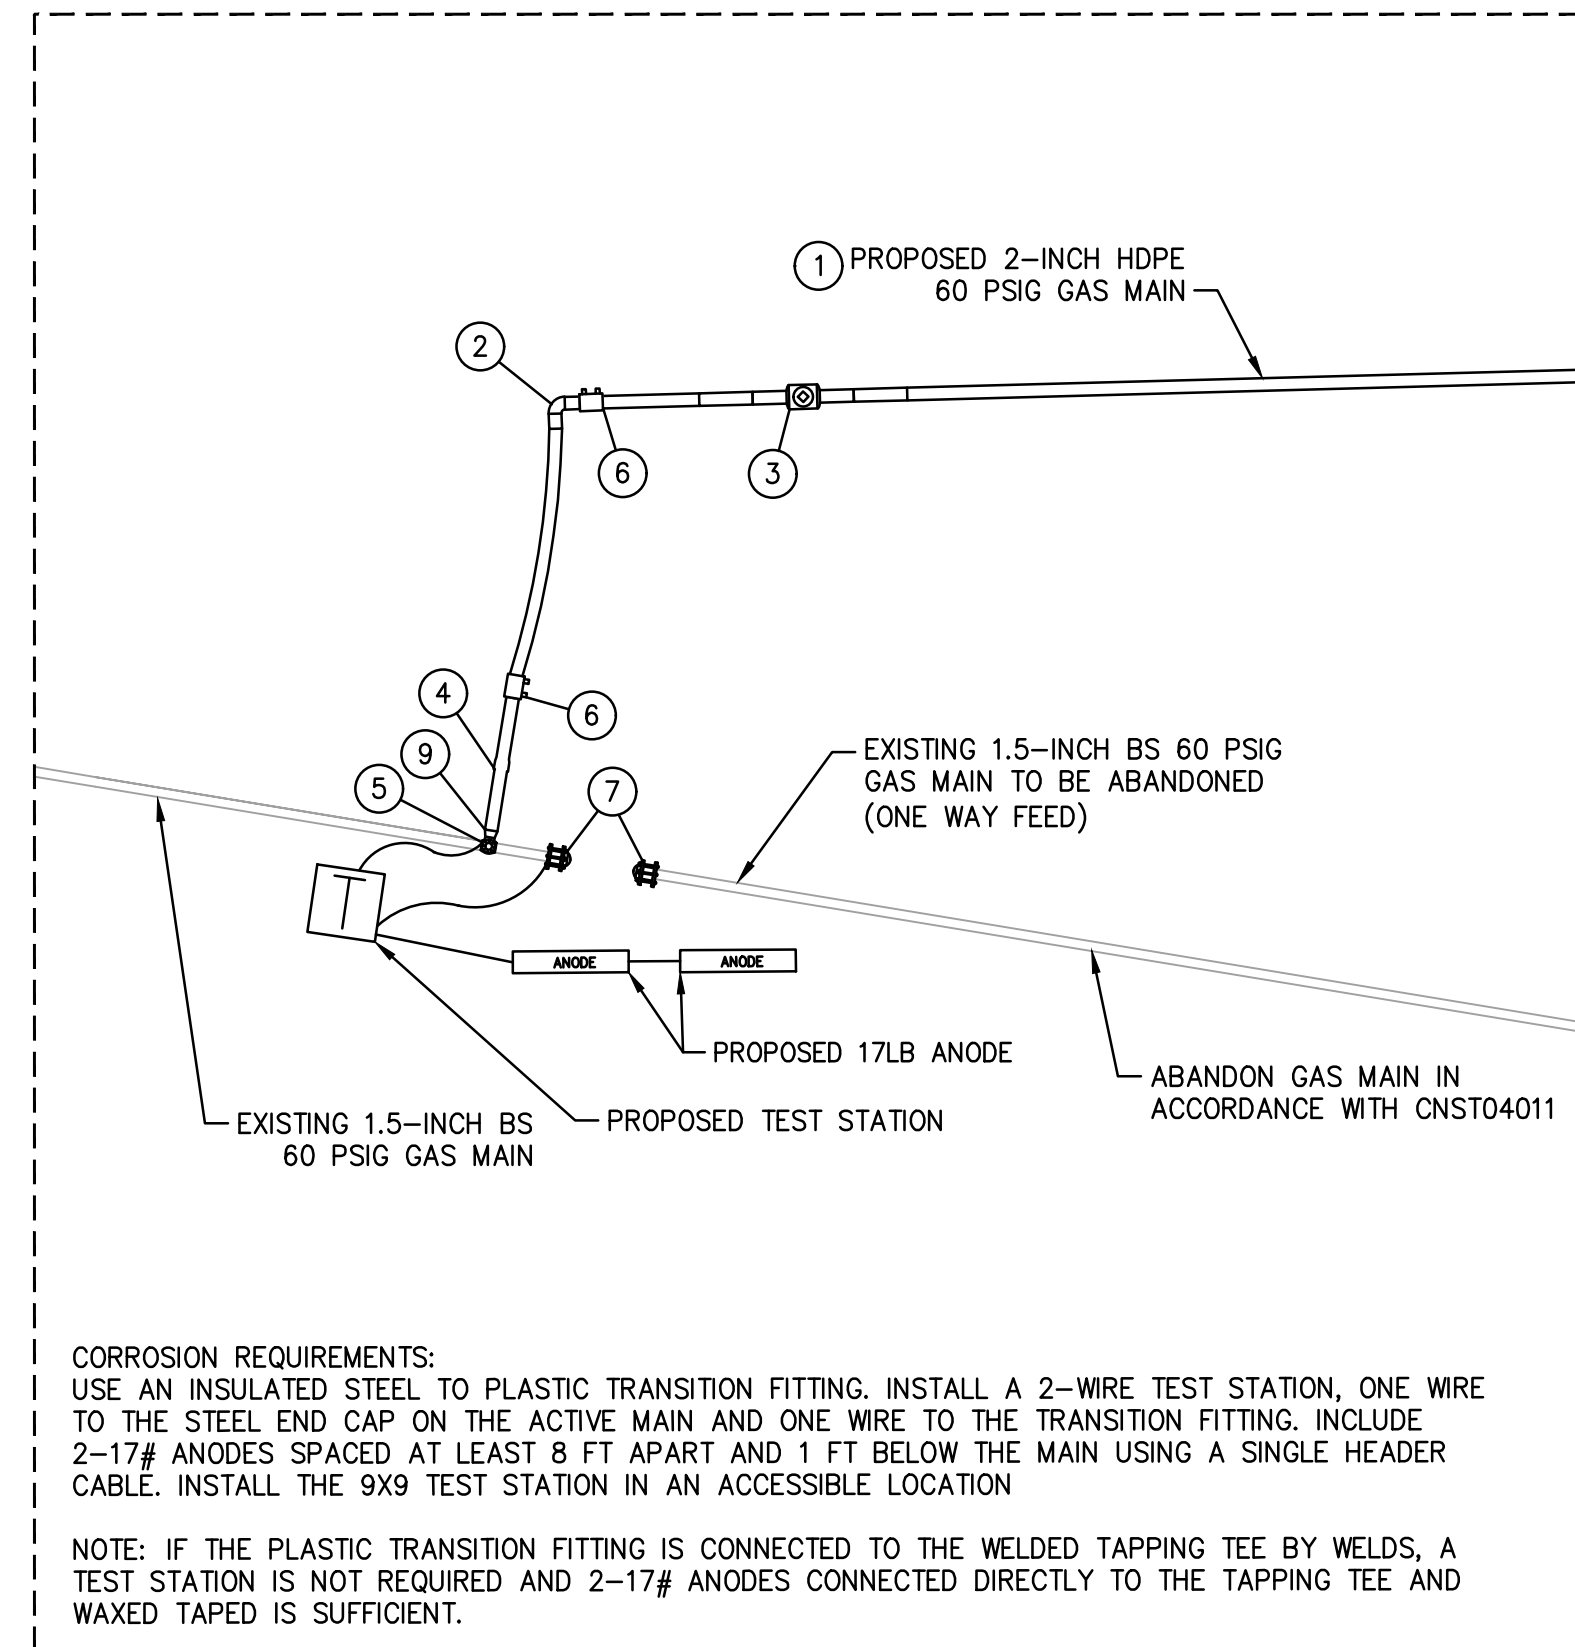

1 PROPOSED TIE-IN AT GREENVALE AVENUE

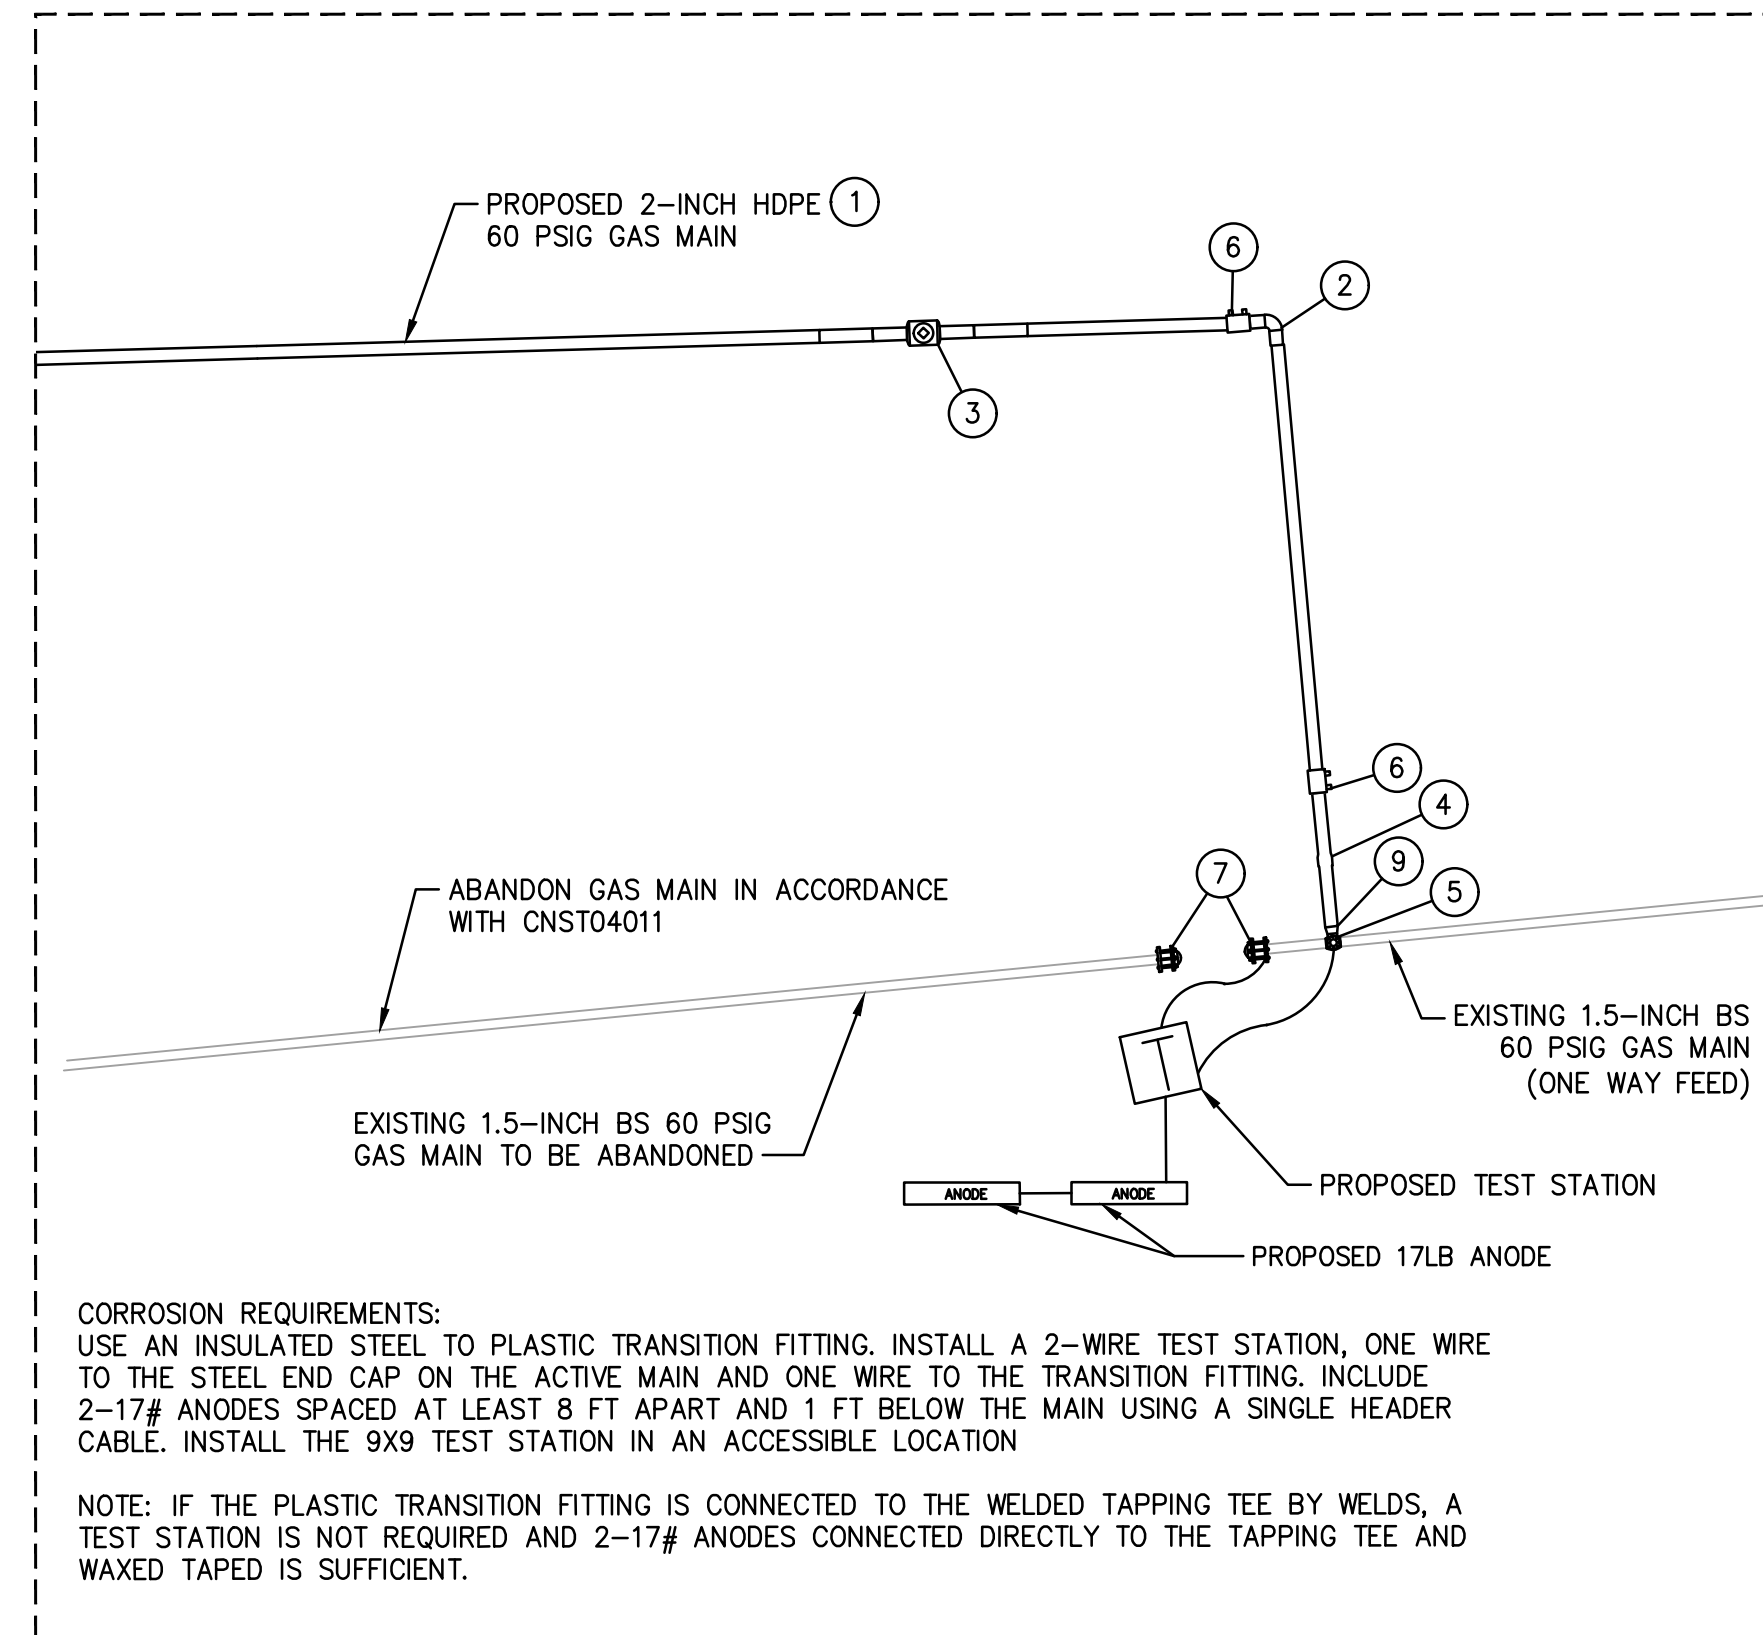

2 PROPOSED TIE-IN AT GREENVALE AVENUE
SCALE: 1"=3'

0	09/01/20	ISSUED FOR CONSTRUCTION	BCW	ARS	ARS	JEO
No	Date	Revision	By	Chkd.	Engr.	Supv.



PROPOSED GAS MAIN INSTALLATION
VIA HDD ACROSS UNNAMED
PERRENIAL TO WHITMAN'S POND
GREENVALE AVENUE, WEYMOUTH, MA

TIE-IN DETAILS

Drawn: ES	Date: 02/26/2020	Scale: AS NOTED
Chkd.: ARS	Design Engr.: ARS	Design Supv.: JEO

CLIENT DRAWING NUMBER

MR-WEY-1217456

Drawn: <i>ES</i>	Date: <i>02/26/2020</i>	Scale: <i>AS NOTED</i>	CAD FILE NAME	CHA SHEET NUMBER
Chkd.: <i>ARS</i>	Design Engr.: <i>ARS</i>	Design Supv.: <i>JEO</i>	<i>058260.dwg</i>	M-001